



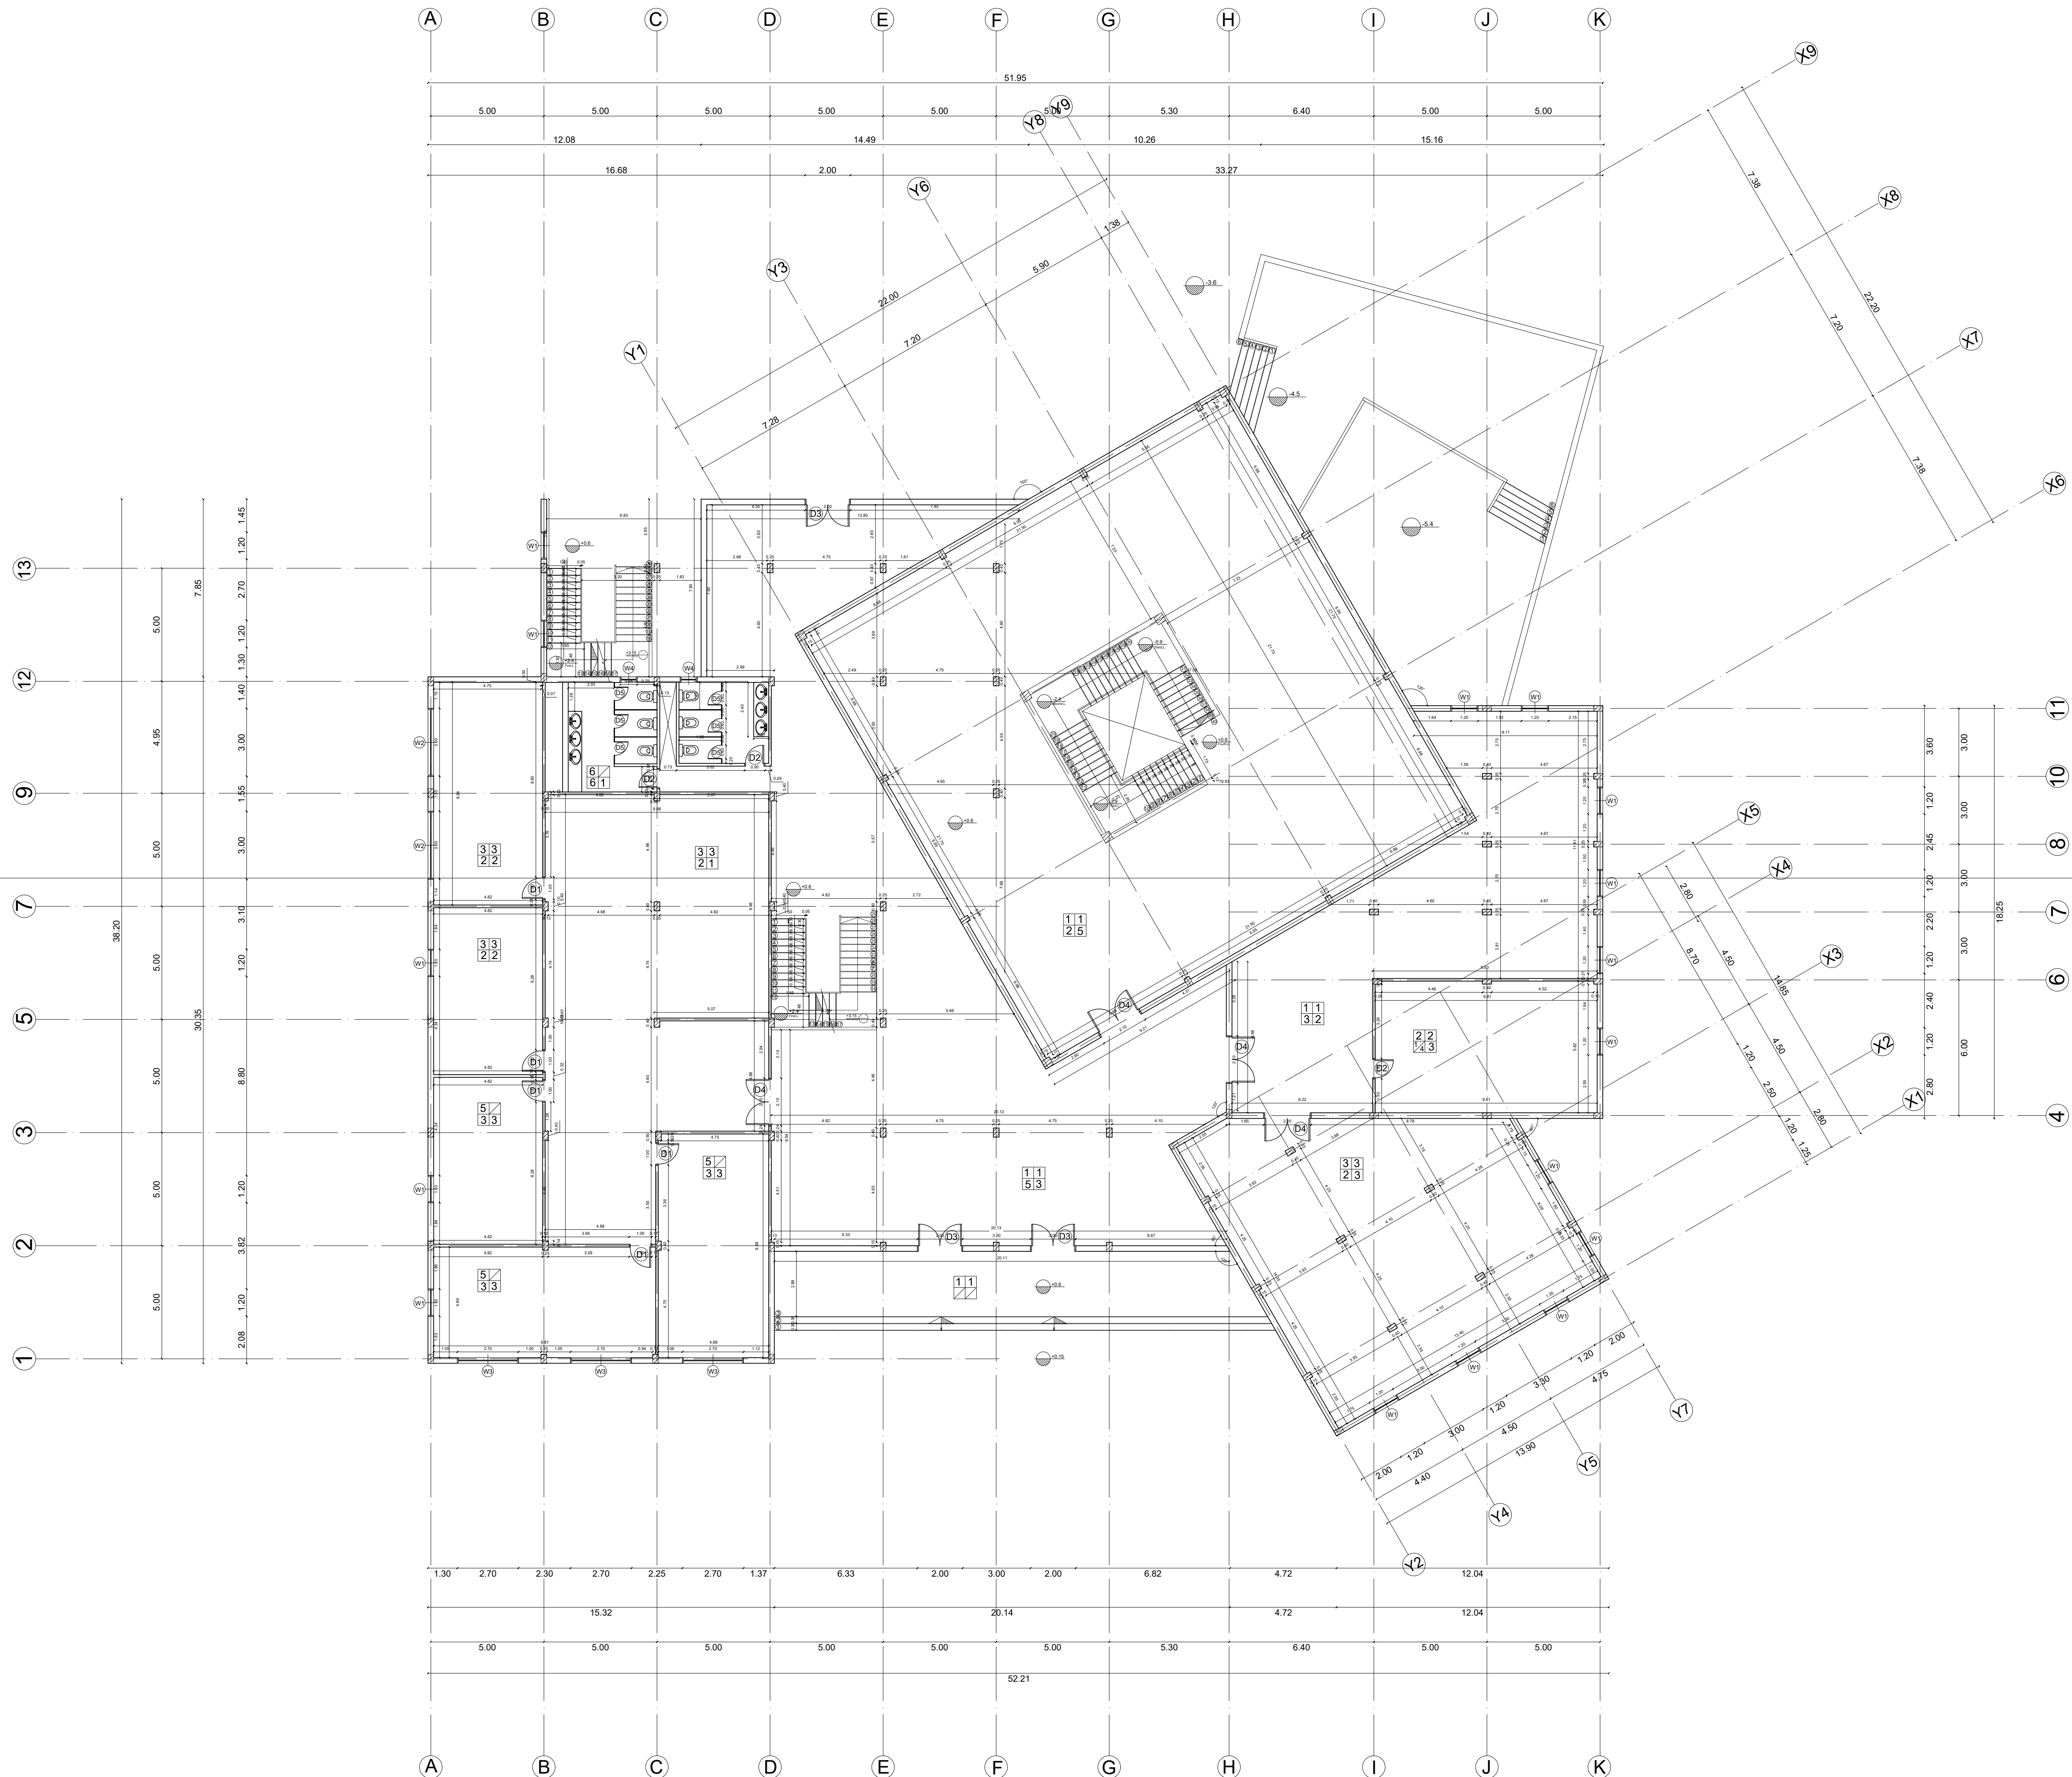

| WINDOWS SCHEDULES |            |        |        |       |          |                  |          |                   |         |
|-------------------|------------|--------|--------|-------|----------|------------------|----------|-------------------|---------|
| SYM               | DIMENSIONS |        | Frame  | SILL  | TYPE     | OPERATION        | MATERIAL | DESCRIPTION       | Elev    |
|                   | WIDTH      | HEIGHT |        |       |          |                  |          |                   |         |
| (W1)              | 1.2 m      | 1.6 m  | 0.05 m | 0.9 m | Casement | Double Side Hung | Glazed   | Double Glazed     | Elev 1  |
| (W2)              | 3 m        | 2.4 m  | 0.05 m | 0.3 m | Casement | Double Side Hung | Glazed   | Double Glazed     | Elev 2  |
| (W3)              | 2.7 m      | 2.4 m  | 0.05 m | 0.3 m | Casement | Double Side Hung | Glazed   | Translucent Glass | Elev 3  |
| (W4)              | 0.75 m     | 0.6 m  | 0.05 m | 1.5 m | Casement | Top Hung         | Glazed   | Translucent Glass | Elev 4  |
| (W5)              | 2 m        | 1.2 m  | 0.05 m | 1.2 m | Casement | Double Side Hung | Glazed   | Double Glazed     | Elev 5  |
| (W6)              | 4.06 m     | 2 m    | 0.05 m | 0.7 m | Casement | Top Hung         | Glazed   | Double Glazed     | Elev 6  |
| (W7)              | 4.34 m     | 2 m    | 0.05 m | 0.7 m | Casement | Top Hung         | Glazed   | Double Glazed     | Elev 7  |
| (W8)              | 4.29 m     | 2 m    | 0.05 m | 0.7 m | Casement | Top Hung         | Glazed   | Double Glazed     | Elev 8  |
| (W9)              | 4.42 m     | 2 m    | 0.05 m | 0.7 m | Casement | Top Hung         | Glazed   | Double Glazed     | Elev 9  |
| (W10)             | 3.6 m      | 2 m    | 0.05 m | 0.7 m | Casement | Top Hung         | Glazed   | Double Glazed     | Elev 10 |

| DOORS SCHEDULES |            |        |        |           |            |              |          |               |        |
|-----------------|------------|--------|--------|-----------|------------|--------------|----------|---------------|--------|
| SYM             | DIMENSIONS |        | Frame  | THICKNESS | TYPE       | OPERATION    | MATERIAL | DESCRIPTION   | Elev.  |
|                 | WIDTH      | HEIGHT |        |           |            |              |          |               |        |
| D1              | 1 m        | 3 m    | 0.05 m | 0.12 m    | paneled    | 1 Side Swing | Wood     | Double Glazed | Elev 3 |
| D2              | 0.9 m      | 2.2 m  | 0.05 m | 0.12 m    | Flush Door | 1 Side Swing | Wood     | Double Glazed | Elev 4 |
| D3              | 2 m        | 2.2 m  | 0.05 m | 0.25 m    | Flush Door | 2 Side Swing | Wood     | Double Glazed | Elev 1 |
| D4              | 2.1 m      | 2.2 m  | 0.05 m | 0.12 m    | paneled    | 2 Side Swing | Wood     | Double Glazed | Elev 2 |
| D5              | 0.75 m     | 3 m    | 0.05 m | 0.02 m    | Flush Door | 1 Side Swing | Phenolic | Double Glazed | Elev 5 |

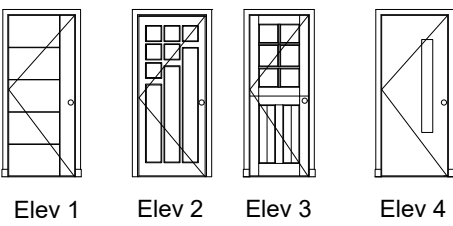

| Flooring |                  |                                                                                                                       |                                 |
|----------|------------------|-----------------------------------------------------------------------------------------------------------------------|---------------------------------|
| NO.      | Materials        | Description                                                                                                           | Dimensions                      |
| 1        | Marble           | Light beige Tuscan Cream marble. A polished, shiny and glossy finish. Installed with cement mortar.                   | 80x80x2 cm                      |
| 2        | Wooden Parquet   | White oak plainsawn wooden parquet, herringbone style. Solid wood.                                                    | 120x90x1.5 cm                   |
| 3        | Wooden strips    | Hard wood flooring. Hickory Blackened Brown wood. Nailed on wooden joists and sleepers.                               | 240x100x1.8 cm                  |
| 4        | Travertine tiles | Buck Light Walnut Polished travertine floor tile.                                                                     | 60x60x2 cm                      |
| 5        | Vinyl            | Heatherfield Tweed - Irish linen vinyl. Low gloss finish. Installed with an adhesive.                                 | Pattern repeats every 540x71 cm |
| 6        | Ceramic tiles    | Copper and bronze steaks are complemented by teal undertones on a light cream base that closely resembles brick work. | 30x30x1 cm                      |

| Skirting |                  |                                                                                                    |               |
|----------|------------------|----------------------------------------------------------------------------------------------------|---------------|
|          | Materials        | Description                                                                                        | Dimensions    |
| 1        | Marble           | Light beige Tuscan Cream marble. A polished, shiny and glossy finish. Installed with cement mortar | 80x10x2 cm    |
| 2        | Wooden Parquet   | White oak plainsawn wooden parquet, herringbone style. Solid wood                                  | 120x10x1.5 cm |
| 3        | Wooden strips    | Hard wood flooring Hickory Blackened Brown wood. Nailed on wooden joists and sleepers              | 300x10x1.5 cm |
| 4        | Travertine tiles | Bucak Light Walnut Polished travertine floor tile                                                  | 45x10x2 cm    |

| Walls     |             |                                                                                                         |                             |
|-----------|-------------|---------------------------------------------------------------------------------------------------------|-----------------------------|
| Materials | Description | Dimensions                                                                                              |                             |
| 1         | Paint       | Wilko Durable Matt Emulsion Paint Biscuit Crunch                                                        |                             |
| 2         | Paint 2     | Wilko Durable Semi Gloss Emulsion Paint Magnolia                                                        |                             |
| 3         | Wall Paper  | Shiro Stripe red model for the east wall                                                                |                             |
| 4         | Wood        | Oak, Tasmanian oak hardwood timber with reddish brown                                                   | 100x15x1.5cm                |
| 5         | Marble      | Statuary gray marble with a polished, shiny and glossy finish, installed with horizontal aluminum rails | 30x60x1.5cm                 |
| 6         | Ceramic     | Mexican Sand Stria mosaic tiles, glossy and frosted finishes                                            | Coverage 10 sq. ft. per box |

Ceiling

|   | Materials         | Description                                                                                   | Dimensions   |
|---|-------------------|-----------------------------------------------------------------------------------------------|--------------|
| 1 | Paint             | creamy color with semi-gloss finish                                                           |              |
| 2 | Acoustic          | white non-reflecting ceiling diffusers interior                                               | 50X50X1.2 cm |
| 3 | Gypsum            | white non-reflecting                                                                          | 90X70X2 cm   |
| 4 | Polyvinyl acetate | white non-reflecting Pvc Ceiling Cladding Interior                                            | 30x30x2 cm   |
| 5 | Wood              | solid oak wooden panels mounted to notched wood backers. The panels suspended with HD 7 Grid. | 120x9x2 cm   |

Prince Sultan University

Arch & ID Department

Student Activity Center

Working Drawing & Detailing II

ID353

Ground Floor Plan






1:100

AR02

Salam Murad


212410018

Dr. Marwa Fahmi

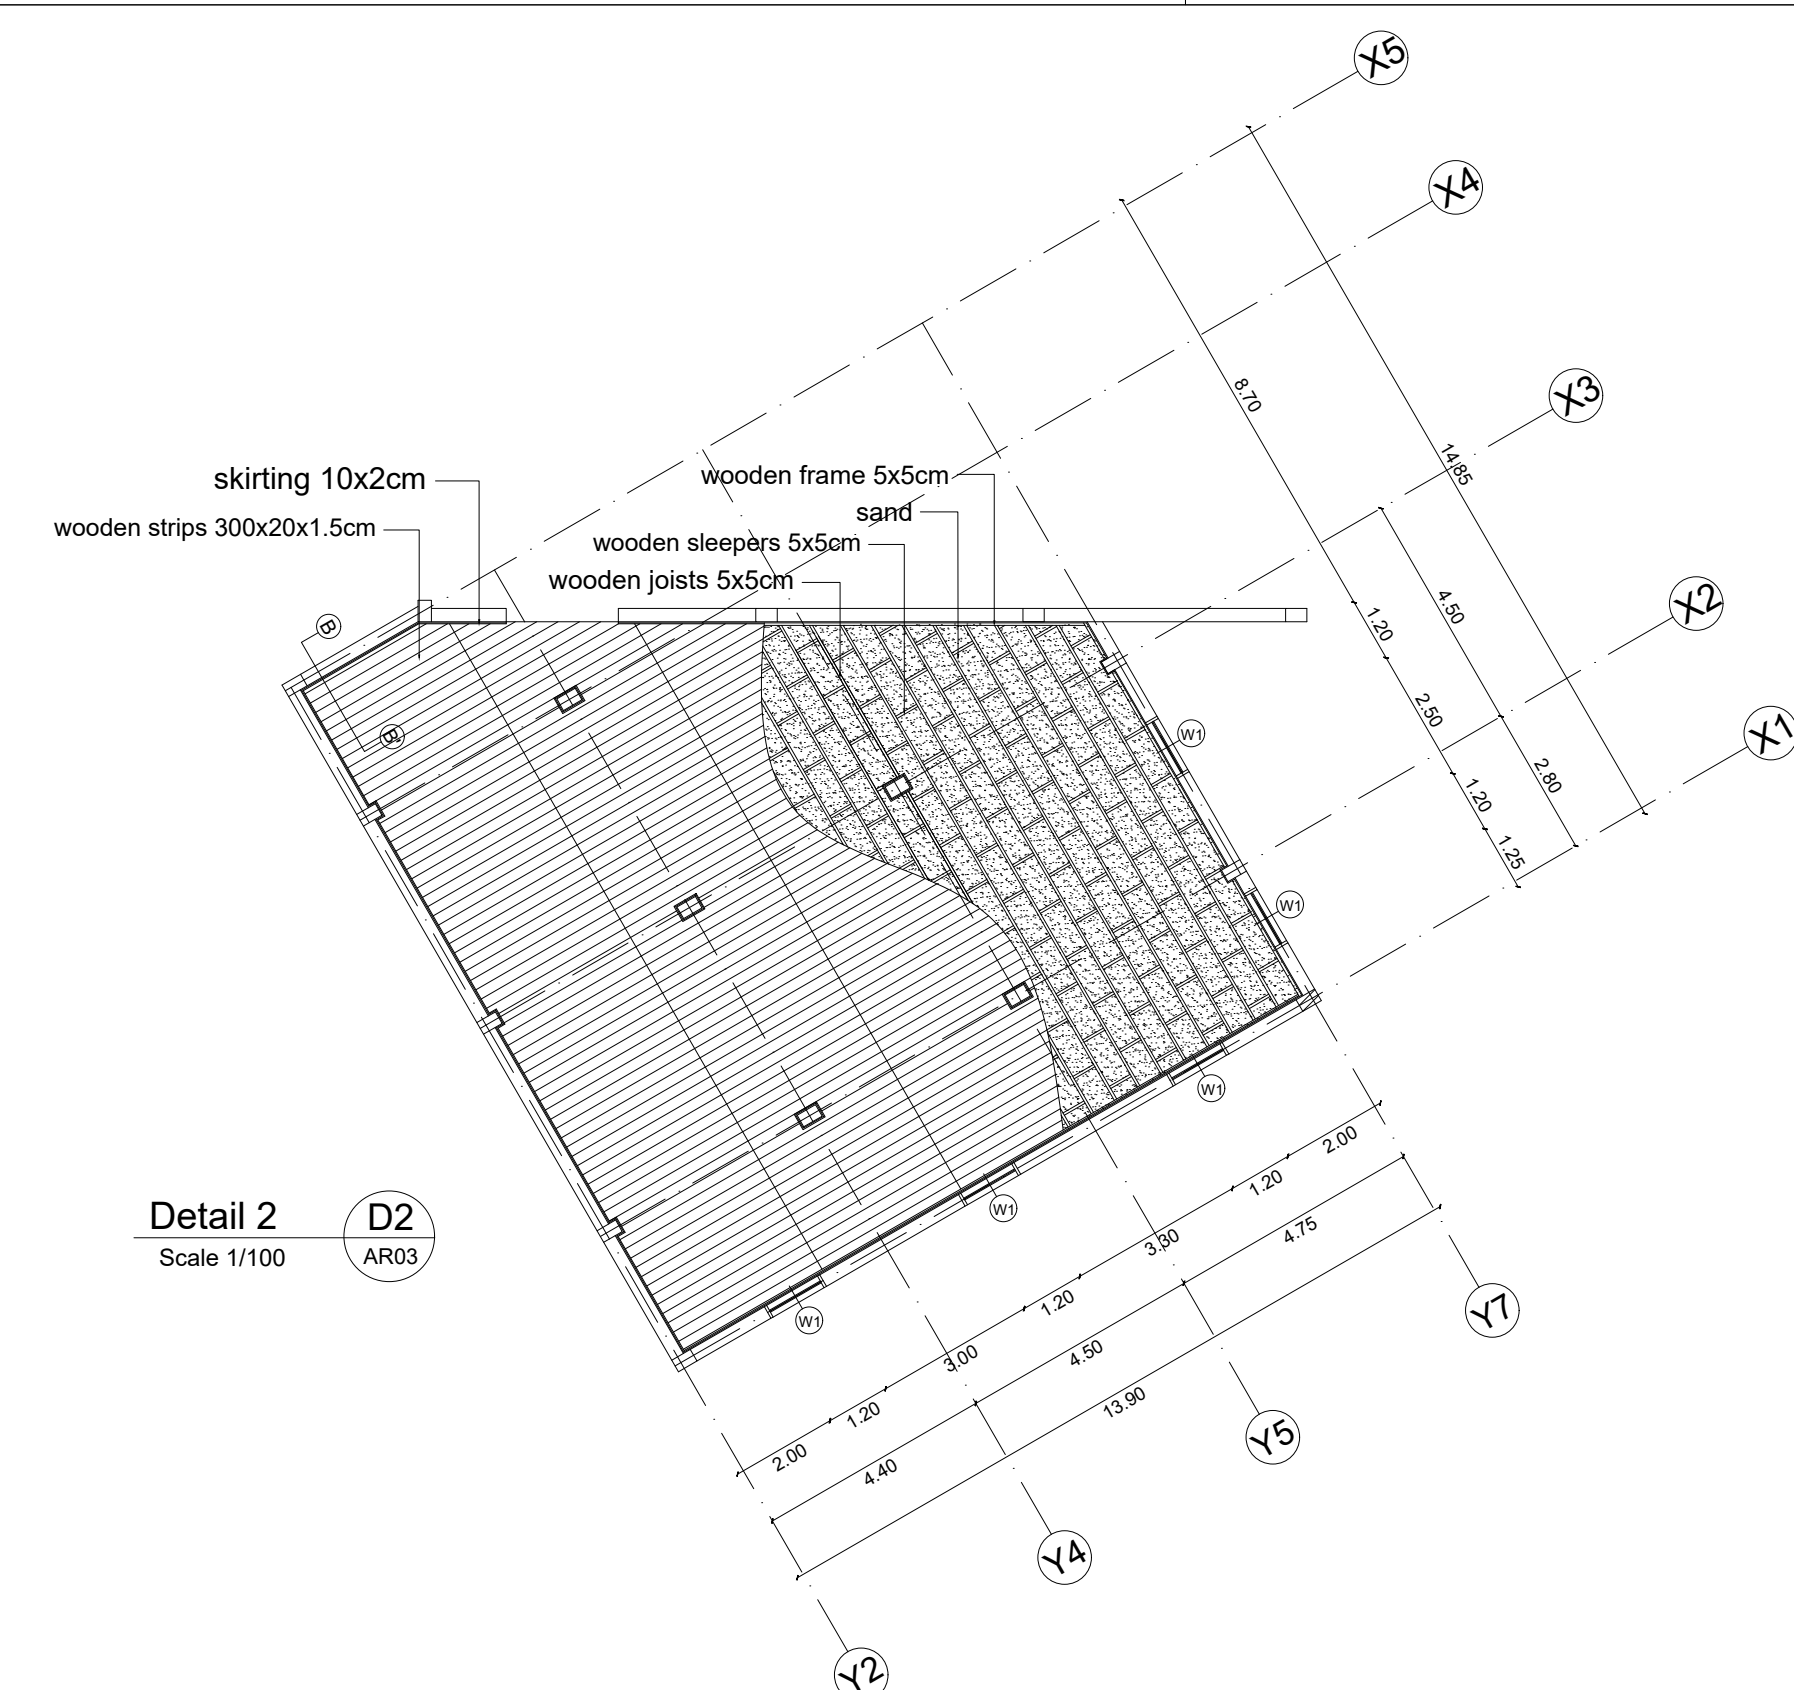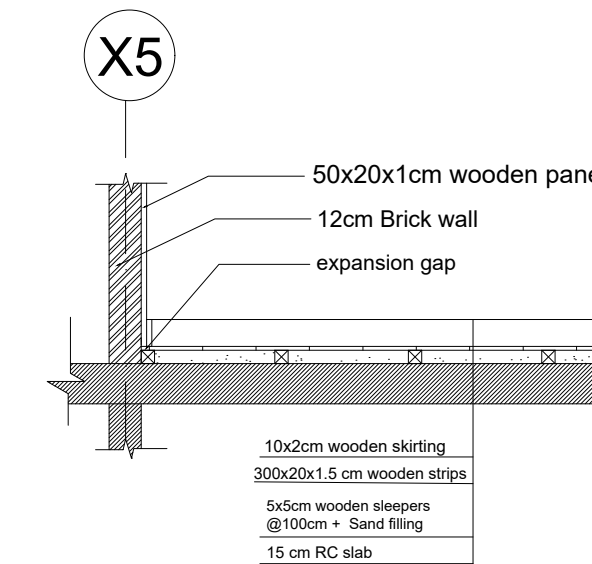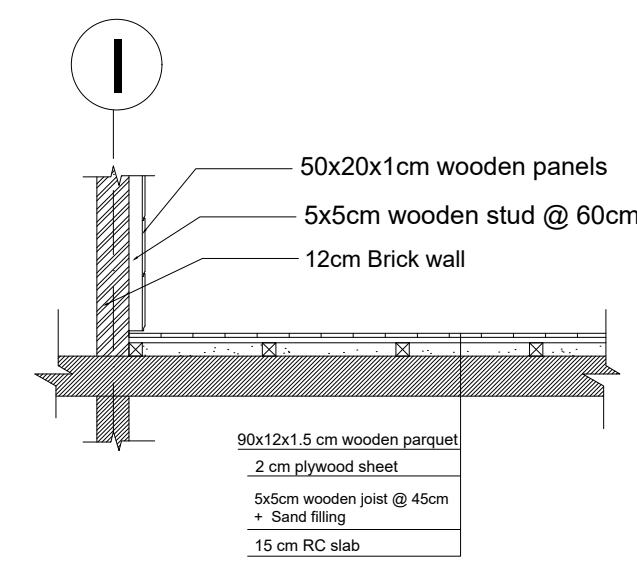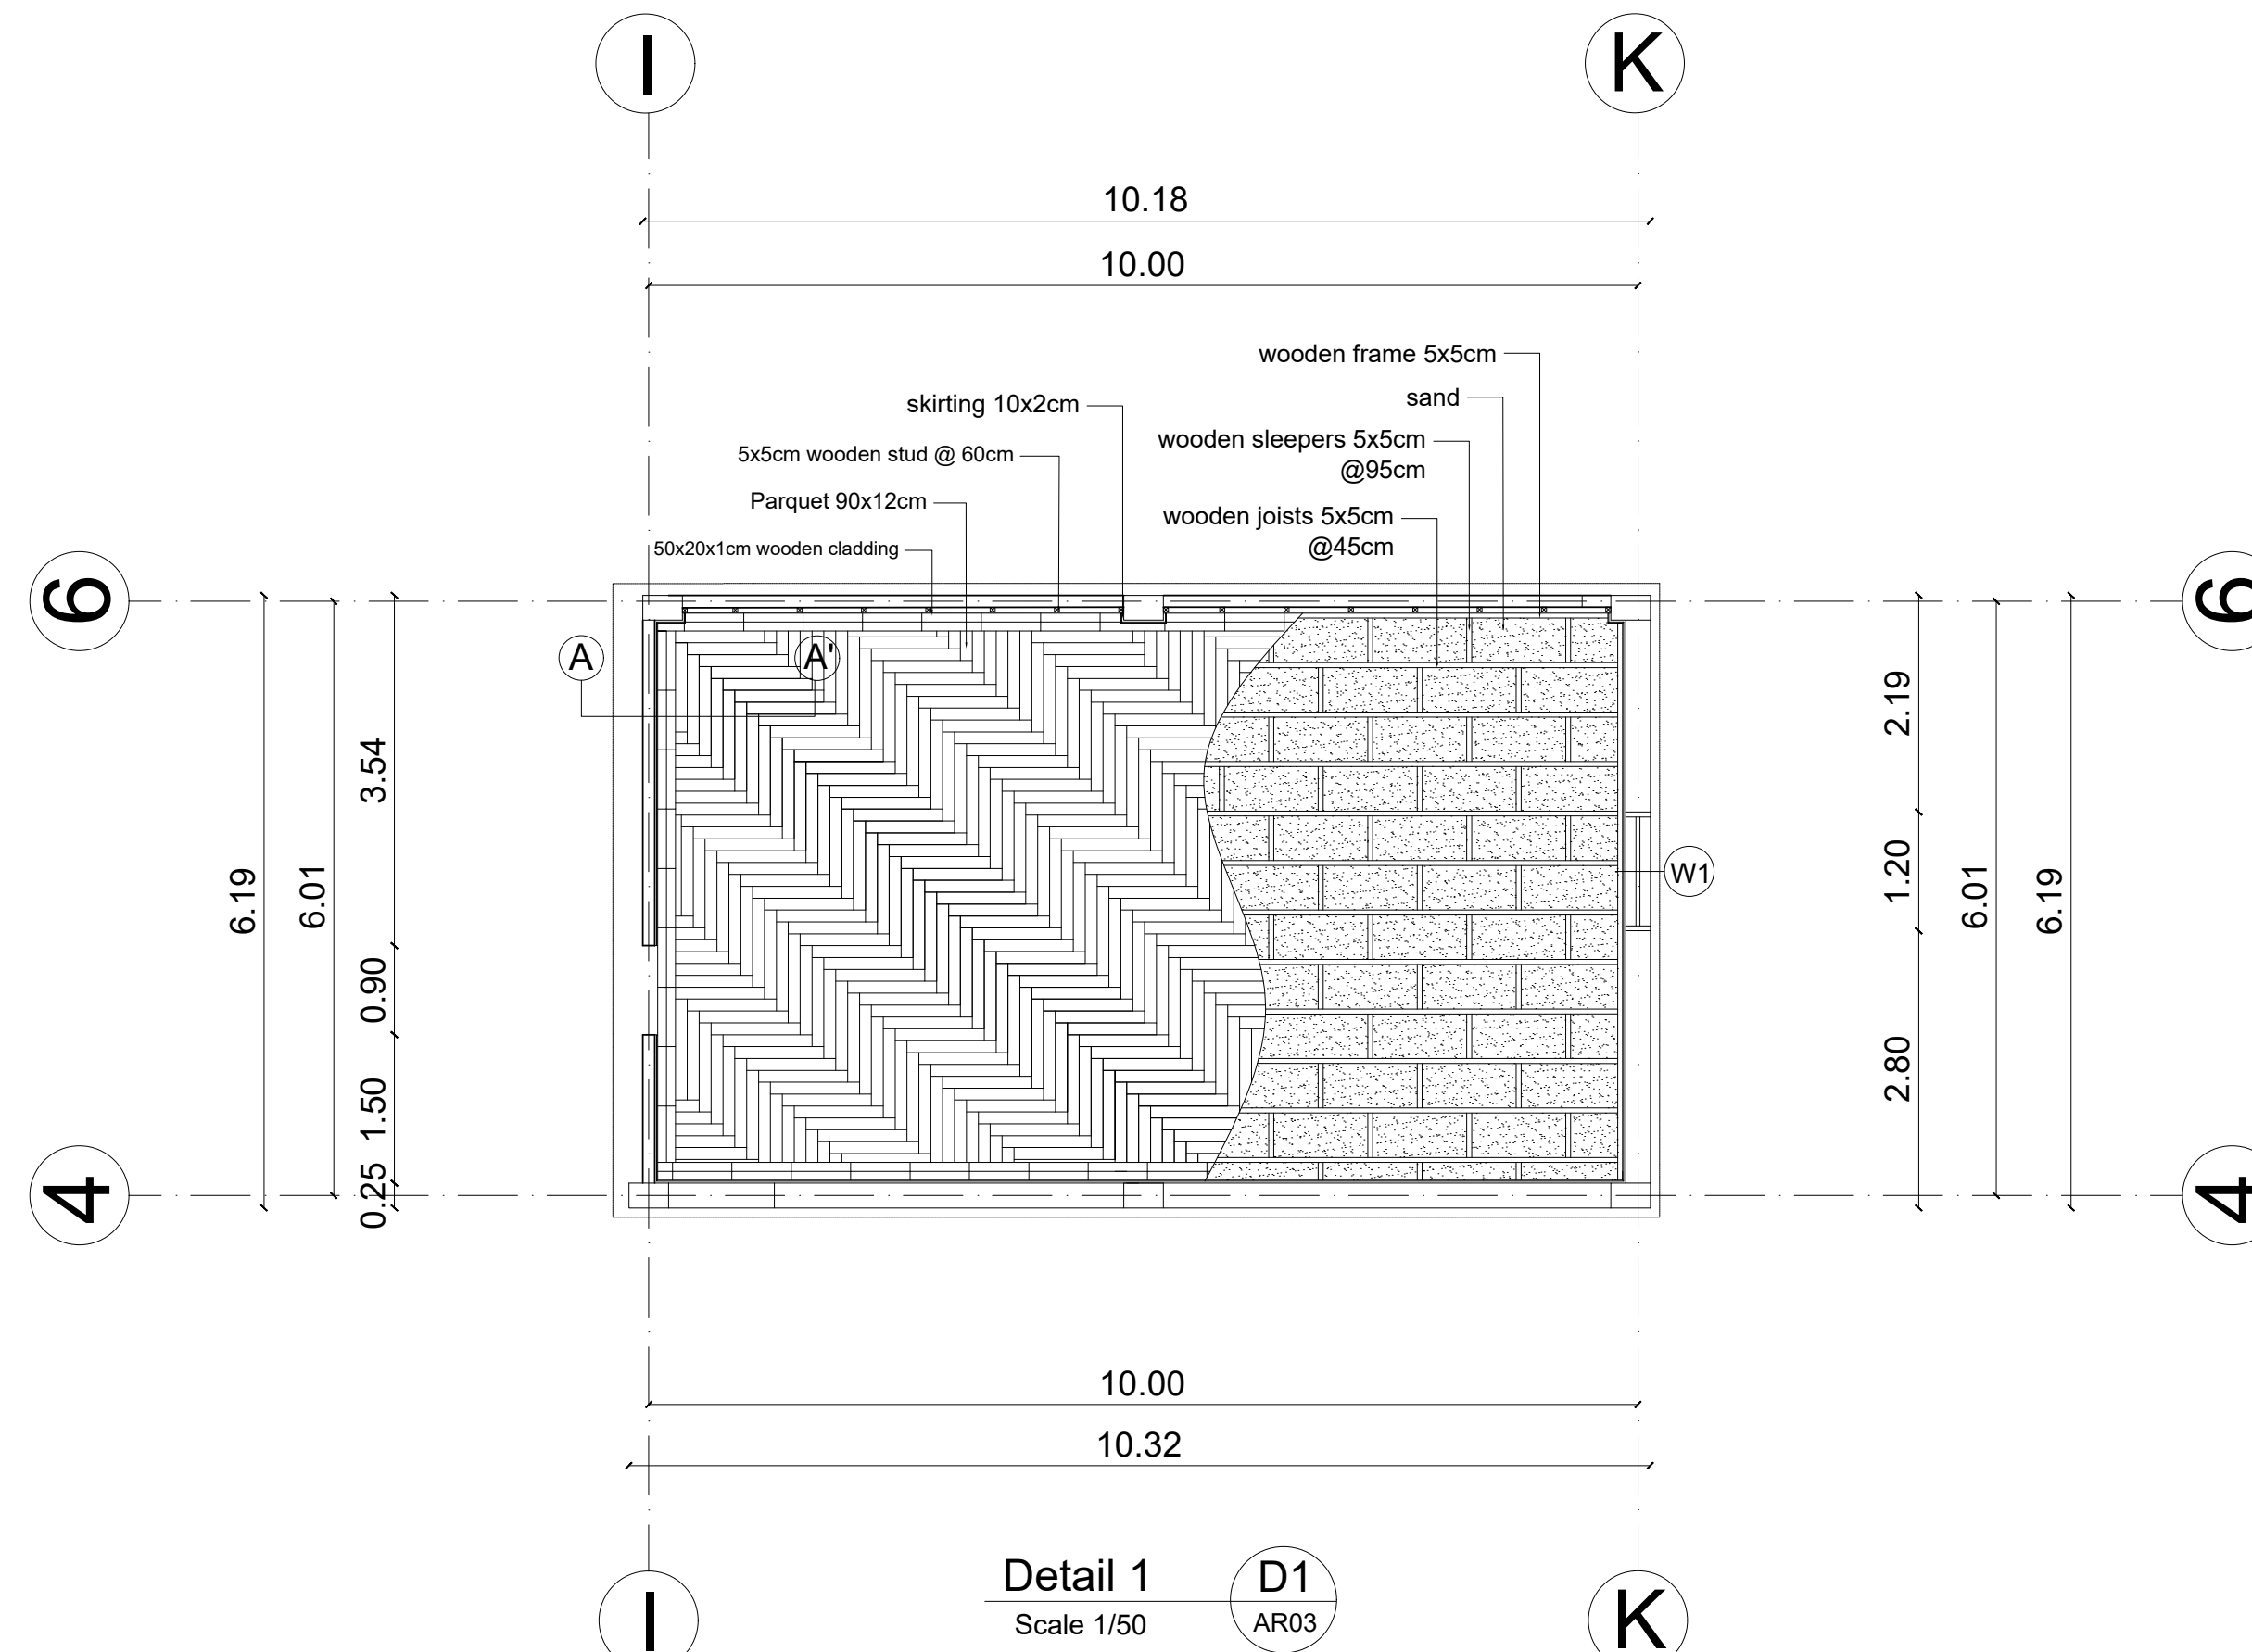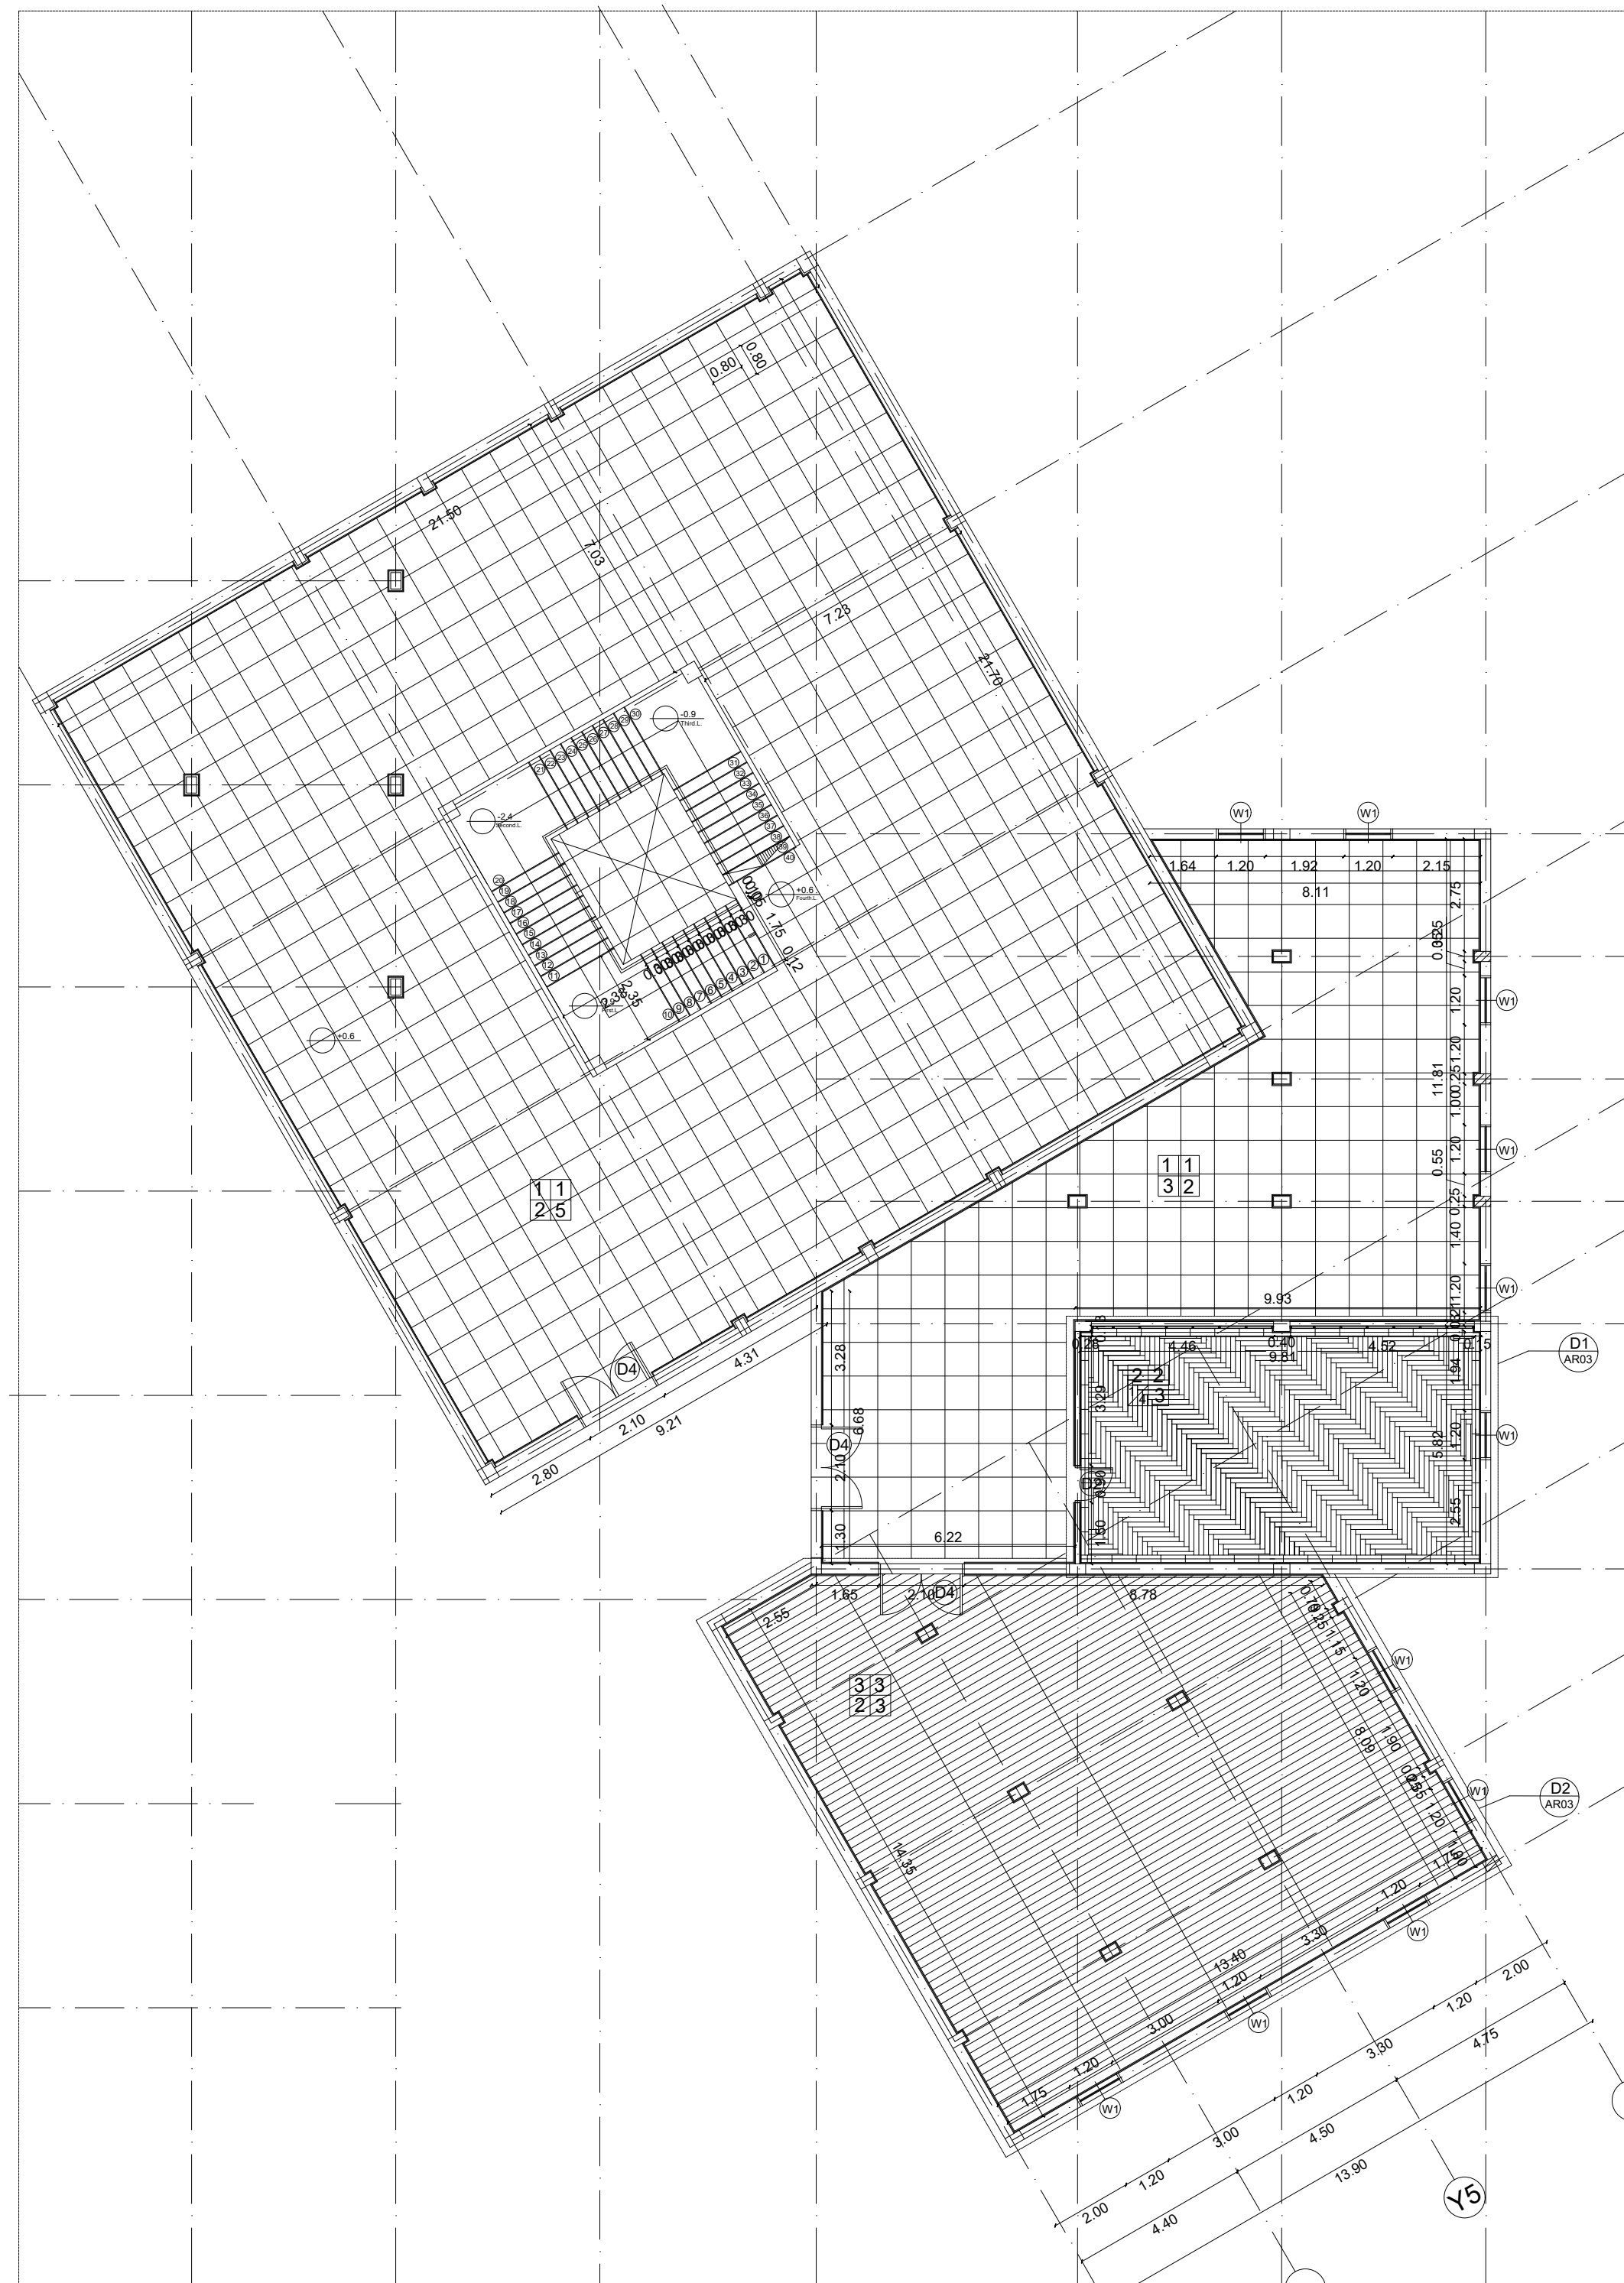

| WINDOWS SCHEDULES |            |        |        |       |          |                  |          |                   |         |
|-------------------|------------|--------|--------|-------|----------|------------------|----------|-------------------|---------|
| SYM               | DIMENSIONS |        | Frame  | SILL  | TYPE     | OPERATION        | MATERIAL | DESCRIPTION       | Elev.   |
|                   | WIDTH      | HEIGHT |        |       |          |                  |          |                   |         |
| (W1)              | 1.2 m      | 1.6 m  | 0.05 m | 0.9 m | Casement | Double Side Hung | Glazed   | Double Glazed     | Elev 1  |
| (W2)              | 3 m        | 2.4 m  | 0.05 m | 0.3 m | Casement | Double Side Hung | Glazed   | Double Glazed     | Elev 2  |
| (W3)              | 2.7 m      | 2.4 m  | 0.05 m | 0.3 m | Casement | Double Side Hung | Glazed   | Translucent Glass | Elev 3  |
| (W4)              | 0.75 m     | 0.6 m  | 0.05 m | 1.5 m | Casement | Top Hung         | Glazed   | Translucent Glass | Elev 4  |
| (W5)              | 2 m        | 1.2 m  | 0.05 m | 1.2 m | Casement | Double Side Hung | Glazed   | Double Glazed     | Elev 5  |
| (W6)              | 4.06 m     | 2 m    | 0.05 m | 0.7 m | Casement | Top Hung         | Glazed   | Double Glazed     | Elev 6  |
| (W7)              | 4.34 m     | 2 m    | 0.05 m | 0.7 m | Casement | Top Hung         | Glazed   | Double Glazed     | Elev 7  |
| (W8)              | 4.29 m     | 2 m    | 0.05 m | 0.7 m | Casement | Top Hung         | Glazed   | Double Glazed     | Elev 8  |
| (W9)              | 4.42 m     | 2 m    | 0.05 m | 0.7 m | Casement | Top Hung         | Glazed   | Double Glazed     | Elev 9  |
| (W10)             | 3.6 m      | 2 m    | 0.05 m | 0.7 m | Casement | Top Hung         | Glazed   | Double Glazed     | Elev 10 |


| DOORS SCHEDULES |            |        |        |           |            |              |          |                 |        |
|-----------------|------------|--------|--------|-----------|------------|--------------|----------|-----------------|--------|
| SYM             | DIMENSIONS |        | Frame  | THICKNESS | TYPE       | OPERATION    | MATERIAL | DESCRIPTION     | Elev.  |
|                 | WIDTH      | HEIGHT |        |           |            |              |          |                 |        |
| (D1)            | 1 m        | 3 m    | 0.05 m | 0.12 m    | paneled    | 1 Side Swing | Wood     | 1.05 m x 3.05 m | Elev 3 |
| (D2)            | 0.9 m      | 2.2 m  | 0.05 m | 0.12 m    | Flush Door | 1 Side Swing | Wood     | 0.91 m x 2.26 m | Elev 4 |
| (D3)            | 2 m        | 2.2 m  | 0.05 m | 0.25 m    | Flush Door | 2 Side Swing | Wood     | 2.06 m x 2.26 m | Elev 1 |
| (D4)            | 2.1 m      | 2.2 m  | 0.05 m | 0.12 m    | paneled    | 2 Side Swing | Wood     | 2.16 m x 2.26 m | Elev 2 |
| (D5)            | 0.75 m     | 3 m    | 0.05 m | 0.02 m    | Flush Door | 1 Side Swing | Phenolic | 0.76 m x 3.05 m | Elev 5 |

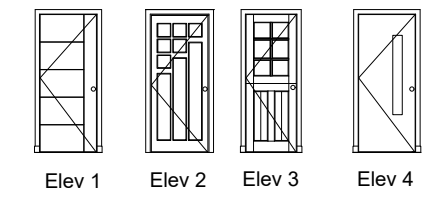


| Flooring |                                                                                                                             |                                                                         |
|----------|-----------------------------------------------------------------------------------------------------------------------------|-------------------------------------------------------------------------|
| NO.      | Materials                                                                                                                   | Dimensions                                                              |
| 1        | Marble<br>Light beige Yucatan cream marble, polished, shiny and glass finish, installed with cement mortar.                 | 80x80x20 mm                                                             |
| 2        | Wooden Parquet<br>White oak plainwood wooden parquet, herringbone style. Solid wood                                         | 120x90x18 mm                                                            |
| 3        | Wooden Strips<br>Hard wood flooring Herring Backed brown wood. Treated on wooden joints and slaps.                          | 240x100x18 mm                                                           |
| 4        | Travelerine tile<br>Beak Light Walnut Polished travelerine floor tile                                                       | 60x60x20 mm                                                             |
| 5        | Vinyl<br>Hearthfield Treaded - Inkish Ink series. Low gloss finish, installed with an adhesive                              | Roll width: 7.5 m<br>Roll length: 15 m<br>Thickness: 5 mm<br>360x720 mm |
| 6        | Ceramic tile<br>Crisp and classic aesthetic is complemented by a subtle color of a hexagon, that clearly defines the space. | 300x300 mm                                                              |


|  <b>Skirting</b> |                 |                                                                                                     |               |
|-----------------------------------------------------------------------------------------------------|-----------------|-----------------------------------------------------------------------------------------------------|---------------|
|                                                                                                     | Materials       | Description                                                                                         | Dimensions    |
| 1                                                                                                   | Marble          | Light beige Tuscany Cream marble. A polished, shiny and glossy finish. Installed with cement mortar | 80x10x2 cm    |
| 2                                                                                                   | Wooden Parquet  | White oak plainnause wooden parquet, herringbone style. Solid wood                                  | 120x10x1.5 cm |
| 3                                                                                                   | Wooden strips   | Hard wood flooring Hickory Blackened Brown wood. Nailed on wooden joists and sleepers               | 300x10x1.5 cm |
| 4                                                                                                   | Traveline tiles | Bucka light Walnut Polished traveline floor tile                                                    | 45x10x2 cm    |

| Walls        |                                                                                                         |                           |
|--------------|---------------------------------------------------------------------------------------------------------|---------------------------|
| Materials    | Description                                                                                             | Dimensions                |
| 1 Paint      | Wilko Durable Matt Emulsion Paint Bisquit Couch                                                         |                           |
| 2 Paint 2    | Wilko Durable Semi Gloss Emulsion Paint Magnolia                                                        |                           |
| 3 Wall Paper | Shiro Stripe red model for the east wall                                                                |                           |
| 4 Wood       | Oak, Tannemian oak handwaxed timber with reddish brown                                                  | 100x15x1.5cm              |
| 5 Marble     | Statuary grey marble with a polished, shiny and glossy finish, installed with horizontal aluminium rods | 30x60x1.5cm               |
| 6 Ceramic    | Mexican Sand Stone mosaic tiles, glossy and polished finish                                             | 30x30x1.5 cm<br>1000/1000 |

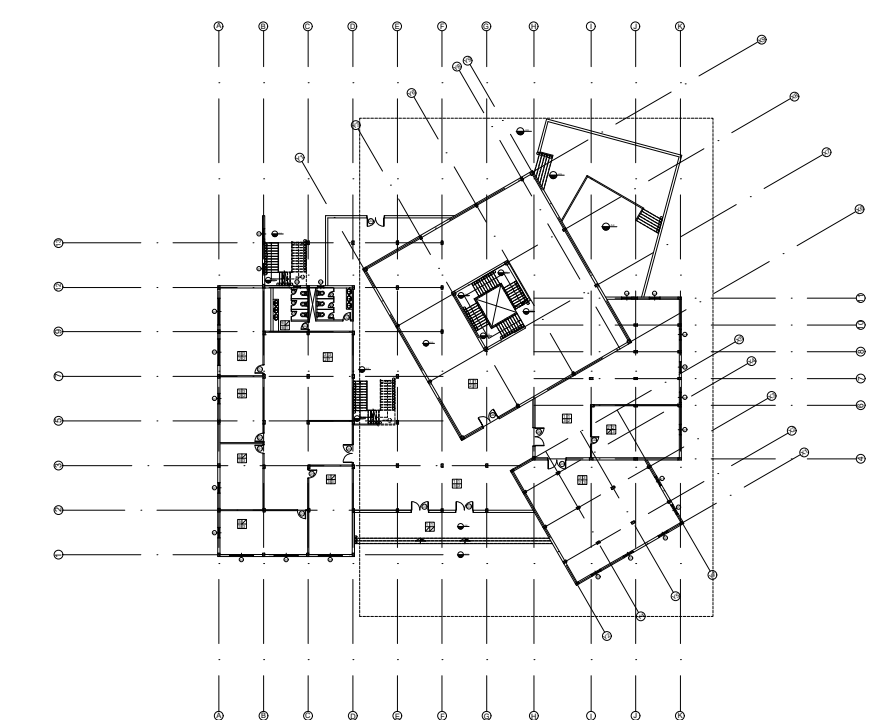

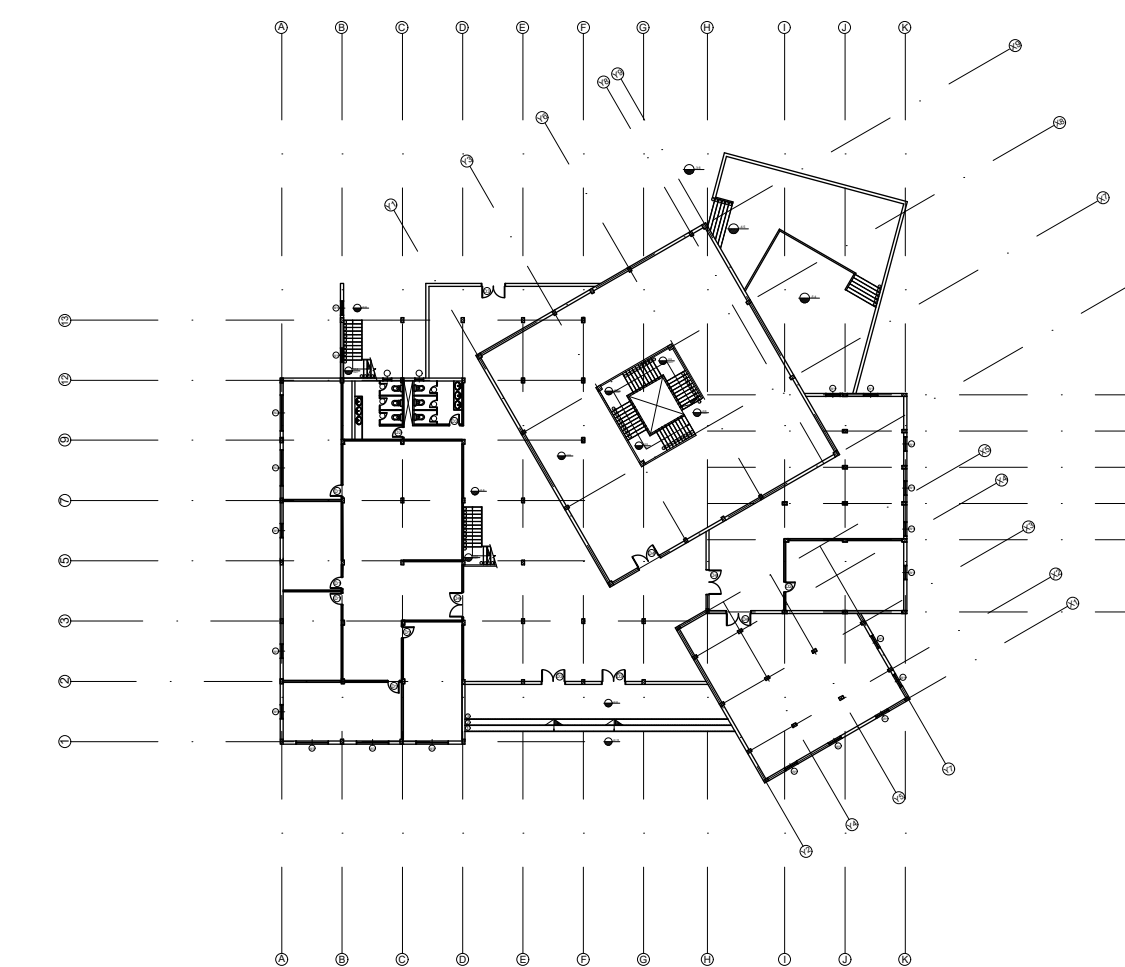

Key Plan: Ground Floor Plan

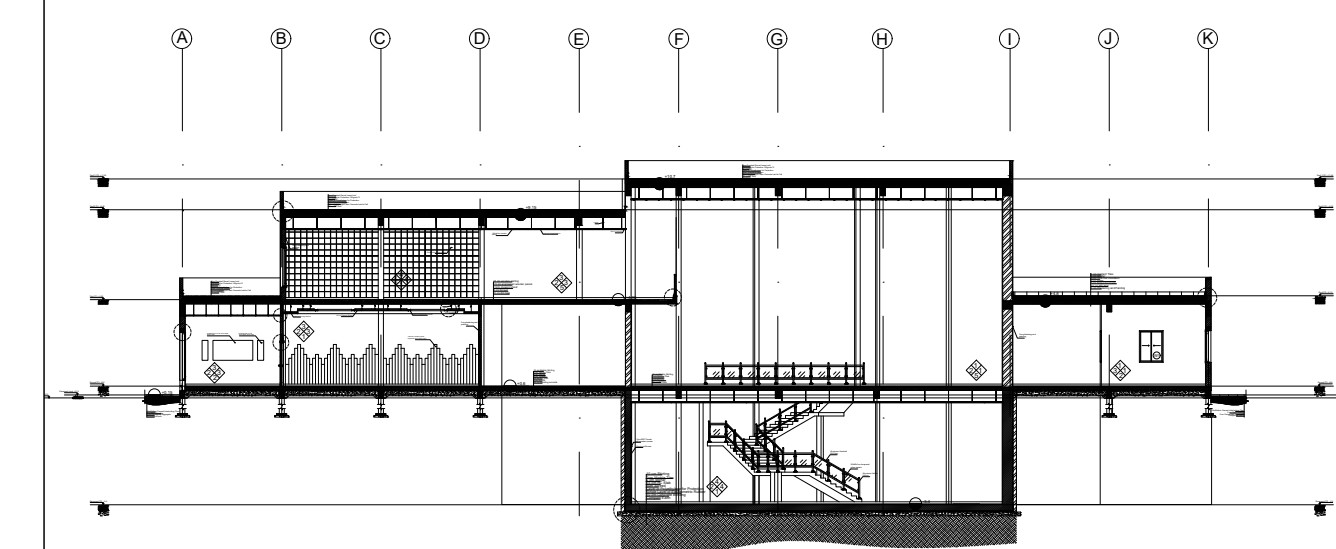

Key Section: Section A-A'

# Prince Sultan University Arch & ID Department Student Activity Center

Working Drawing &  
Detailing II

ID353


Doors I

AR04

Salam Murad

212410018

Dr. Marwa Fahmi

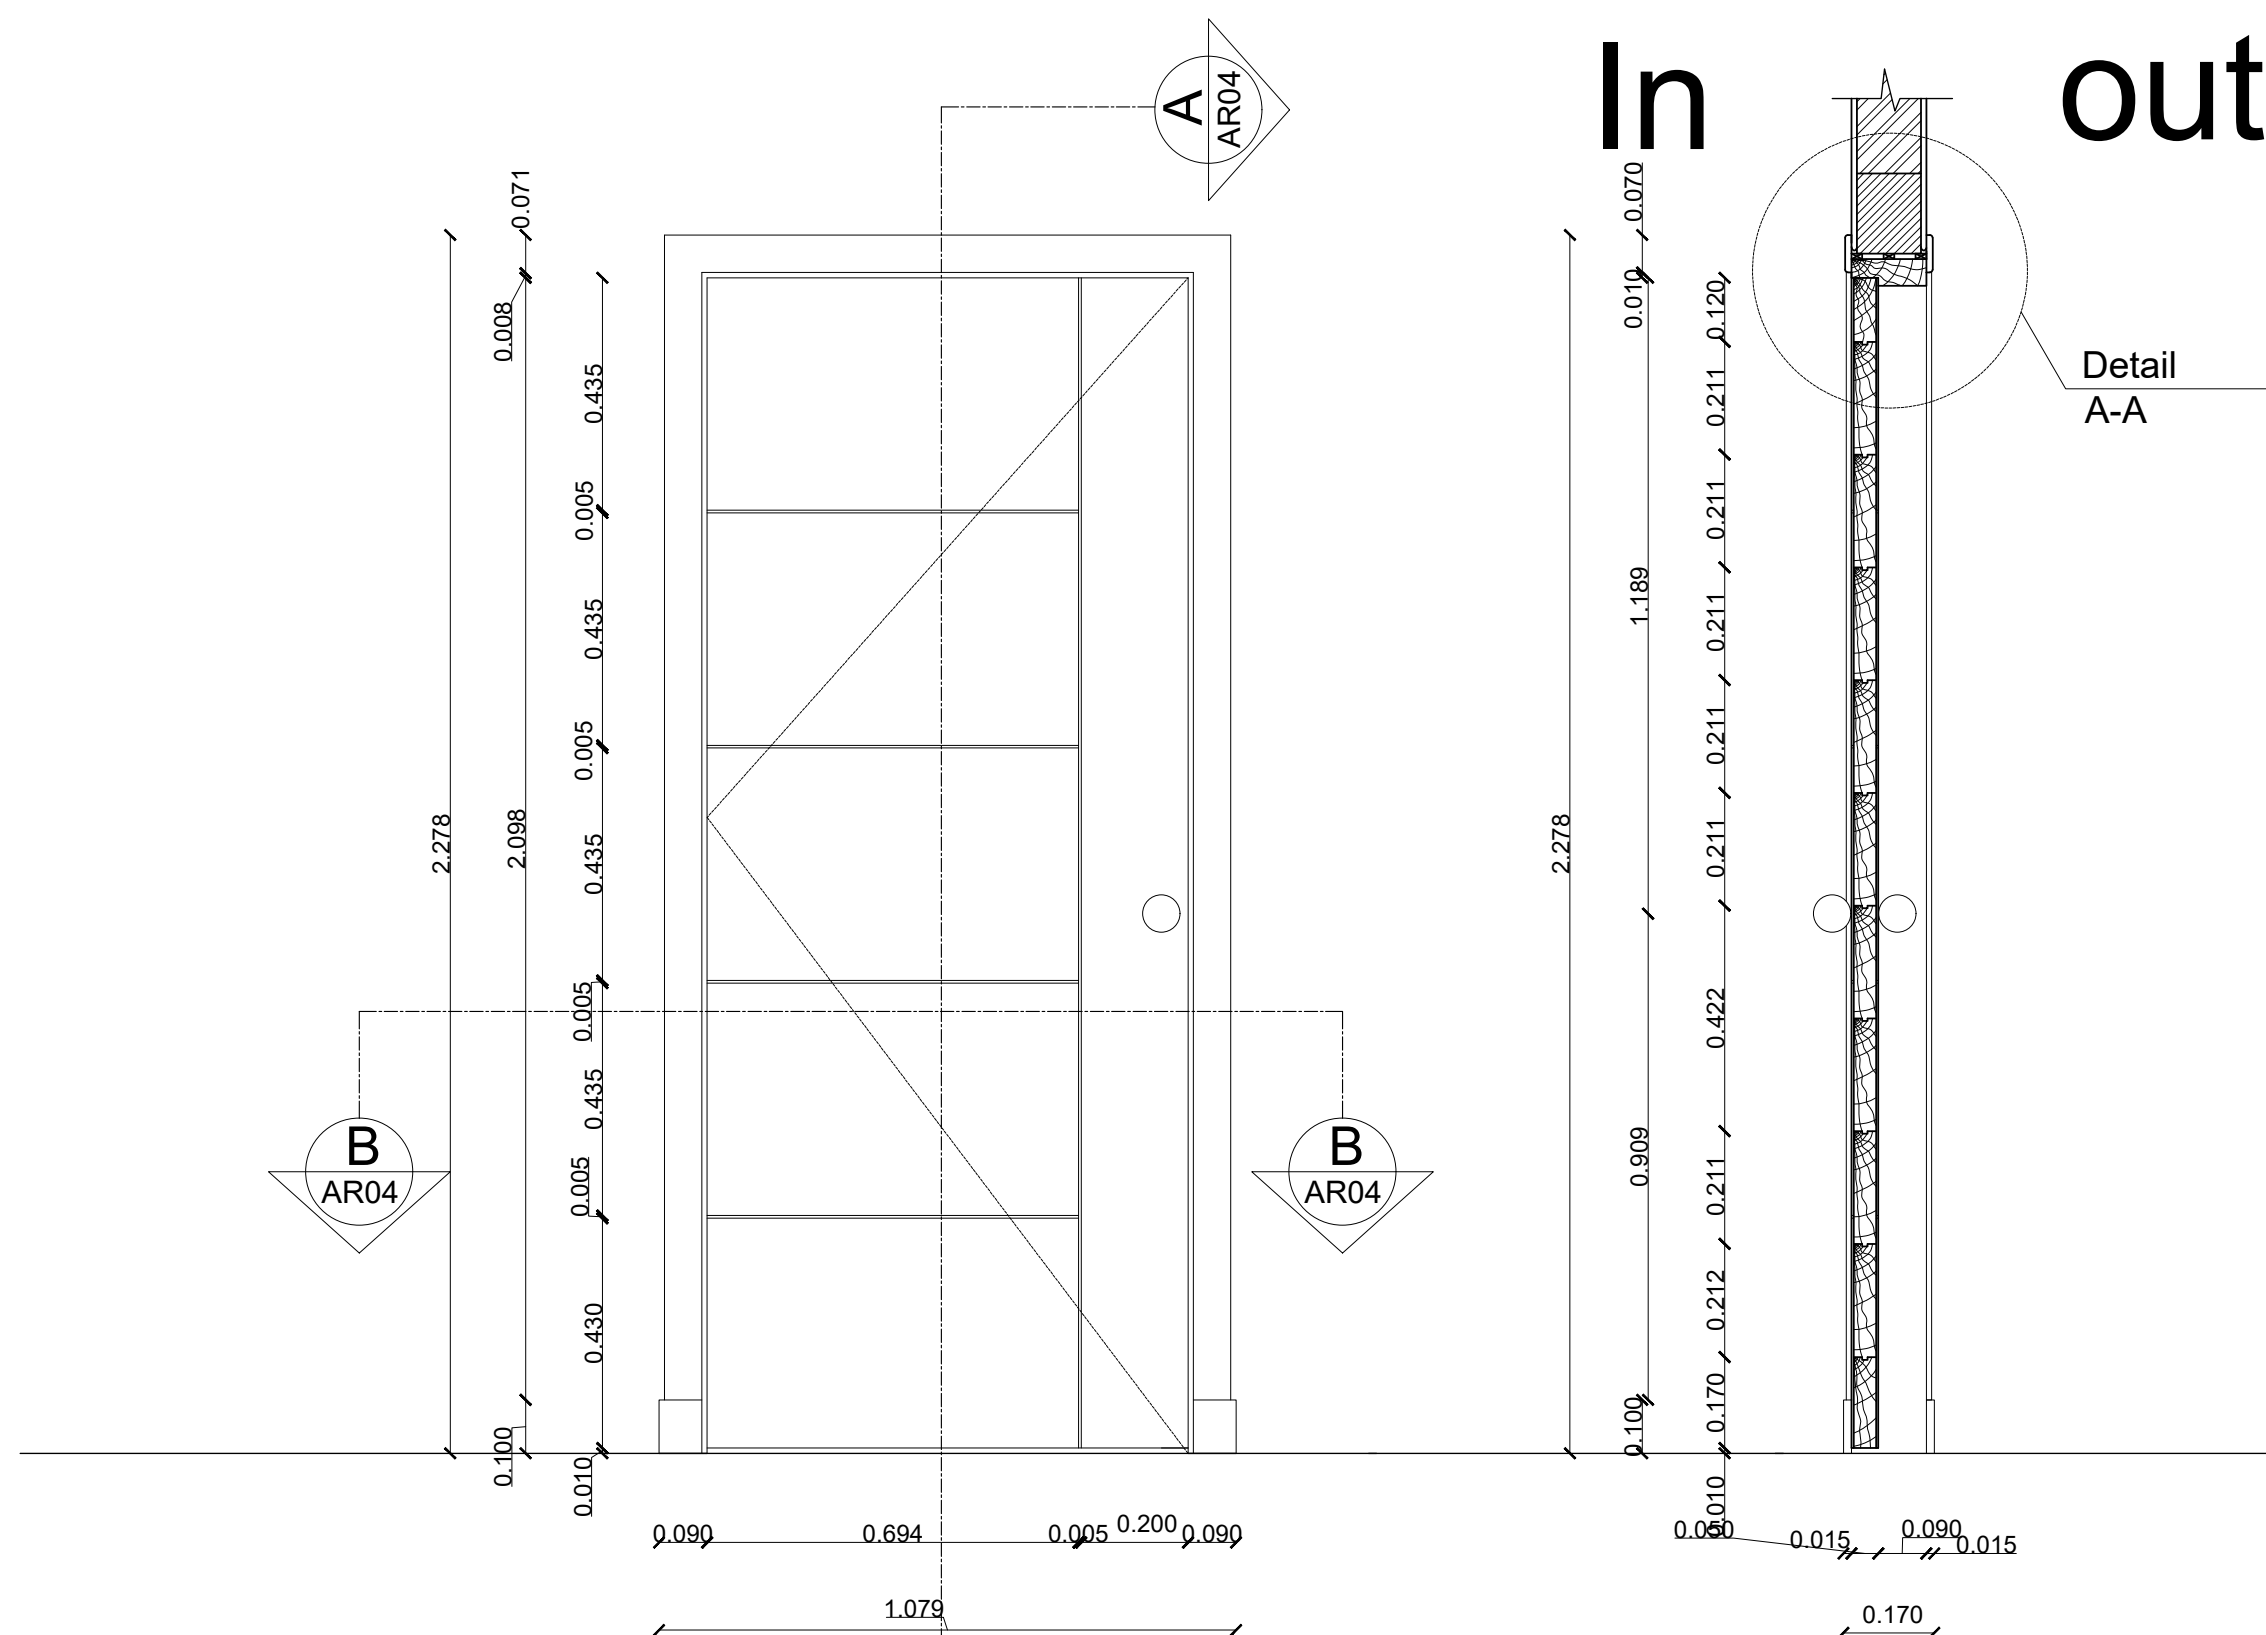


Typical Detail for Wooden Flush door  
Door Elevation/D3 Scale 1:10

1-A  
AR04


Typical Detail for Wooden Flush door  
longitudinal section A-A'/D3 Scale 1:10

1-B  
AR04

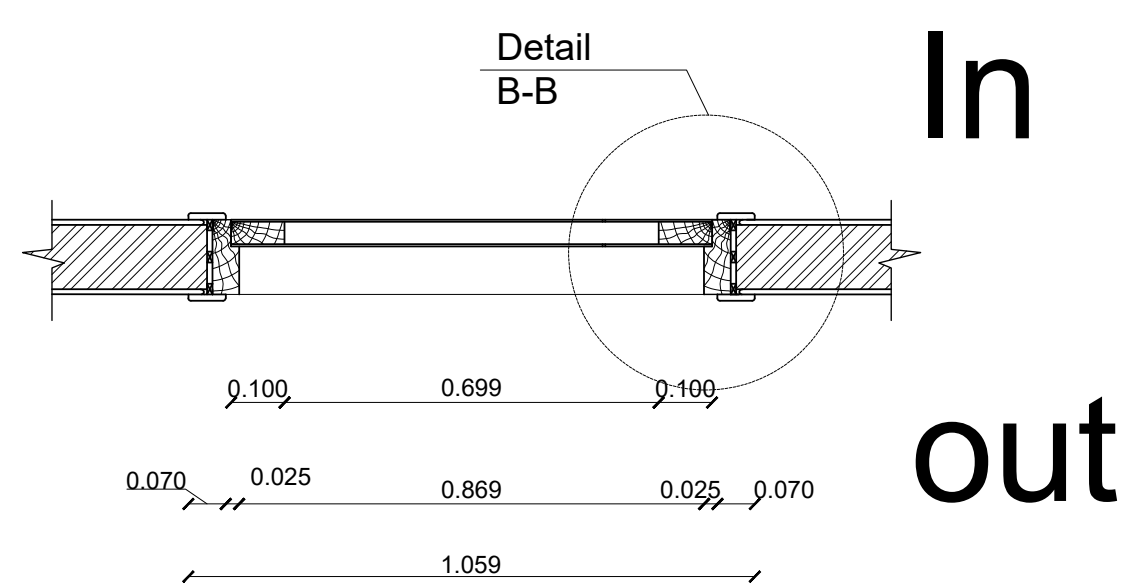


Typical Detail for Wooden Flush door  
Transferal section B-B'/D3 Scale 1:10

1-C  
AR04

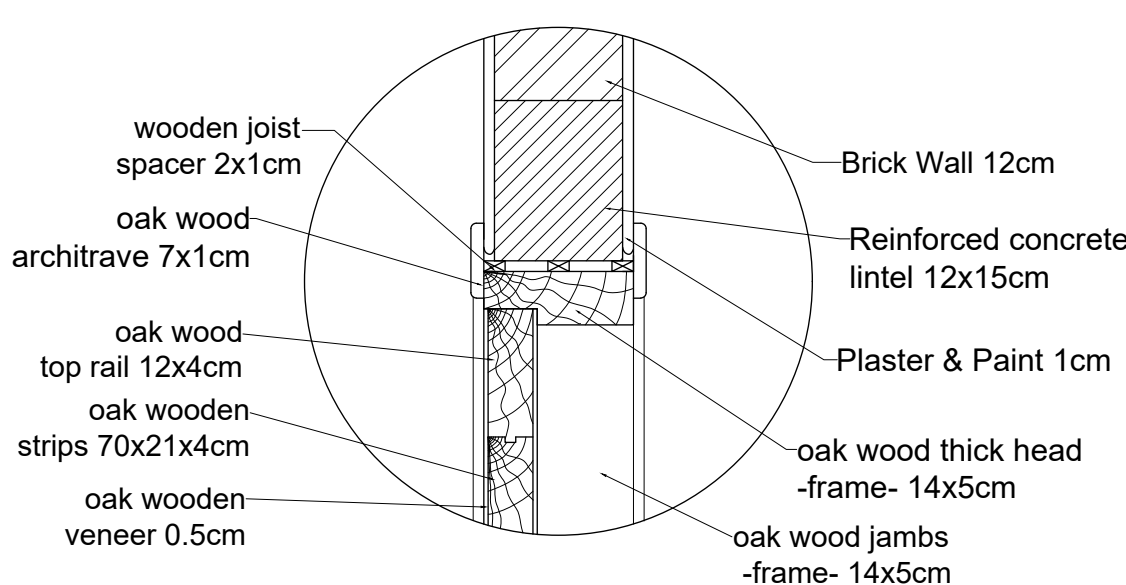


Typical Detail for Wooden Flush door  
Detail A-A Scale 1:5

1-1  
AR04

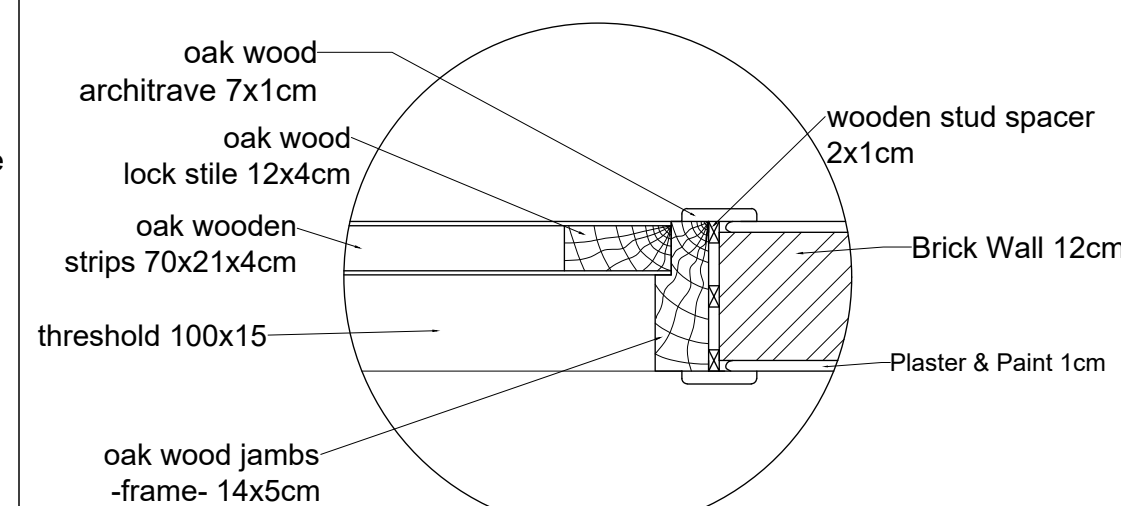

Typical Detail for Wooden Flush door  
Detail B-B Scale 1:5

1-2  
AR04

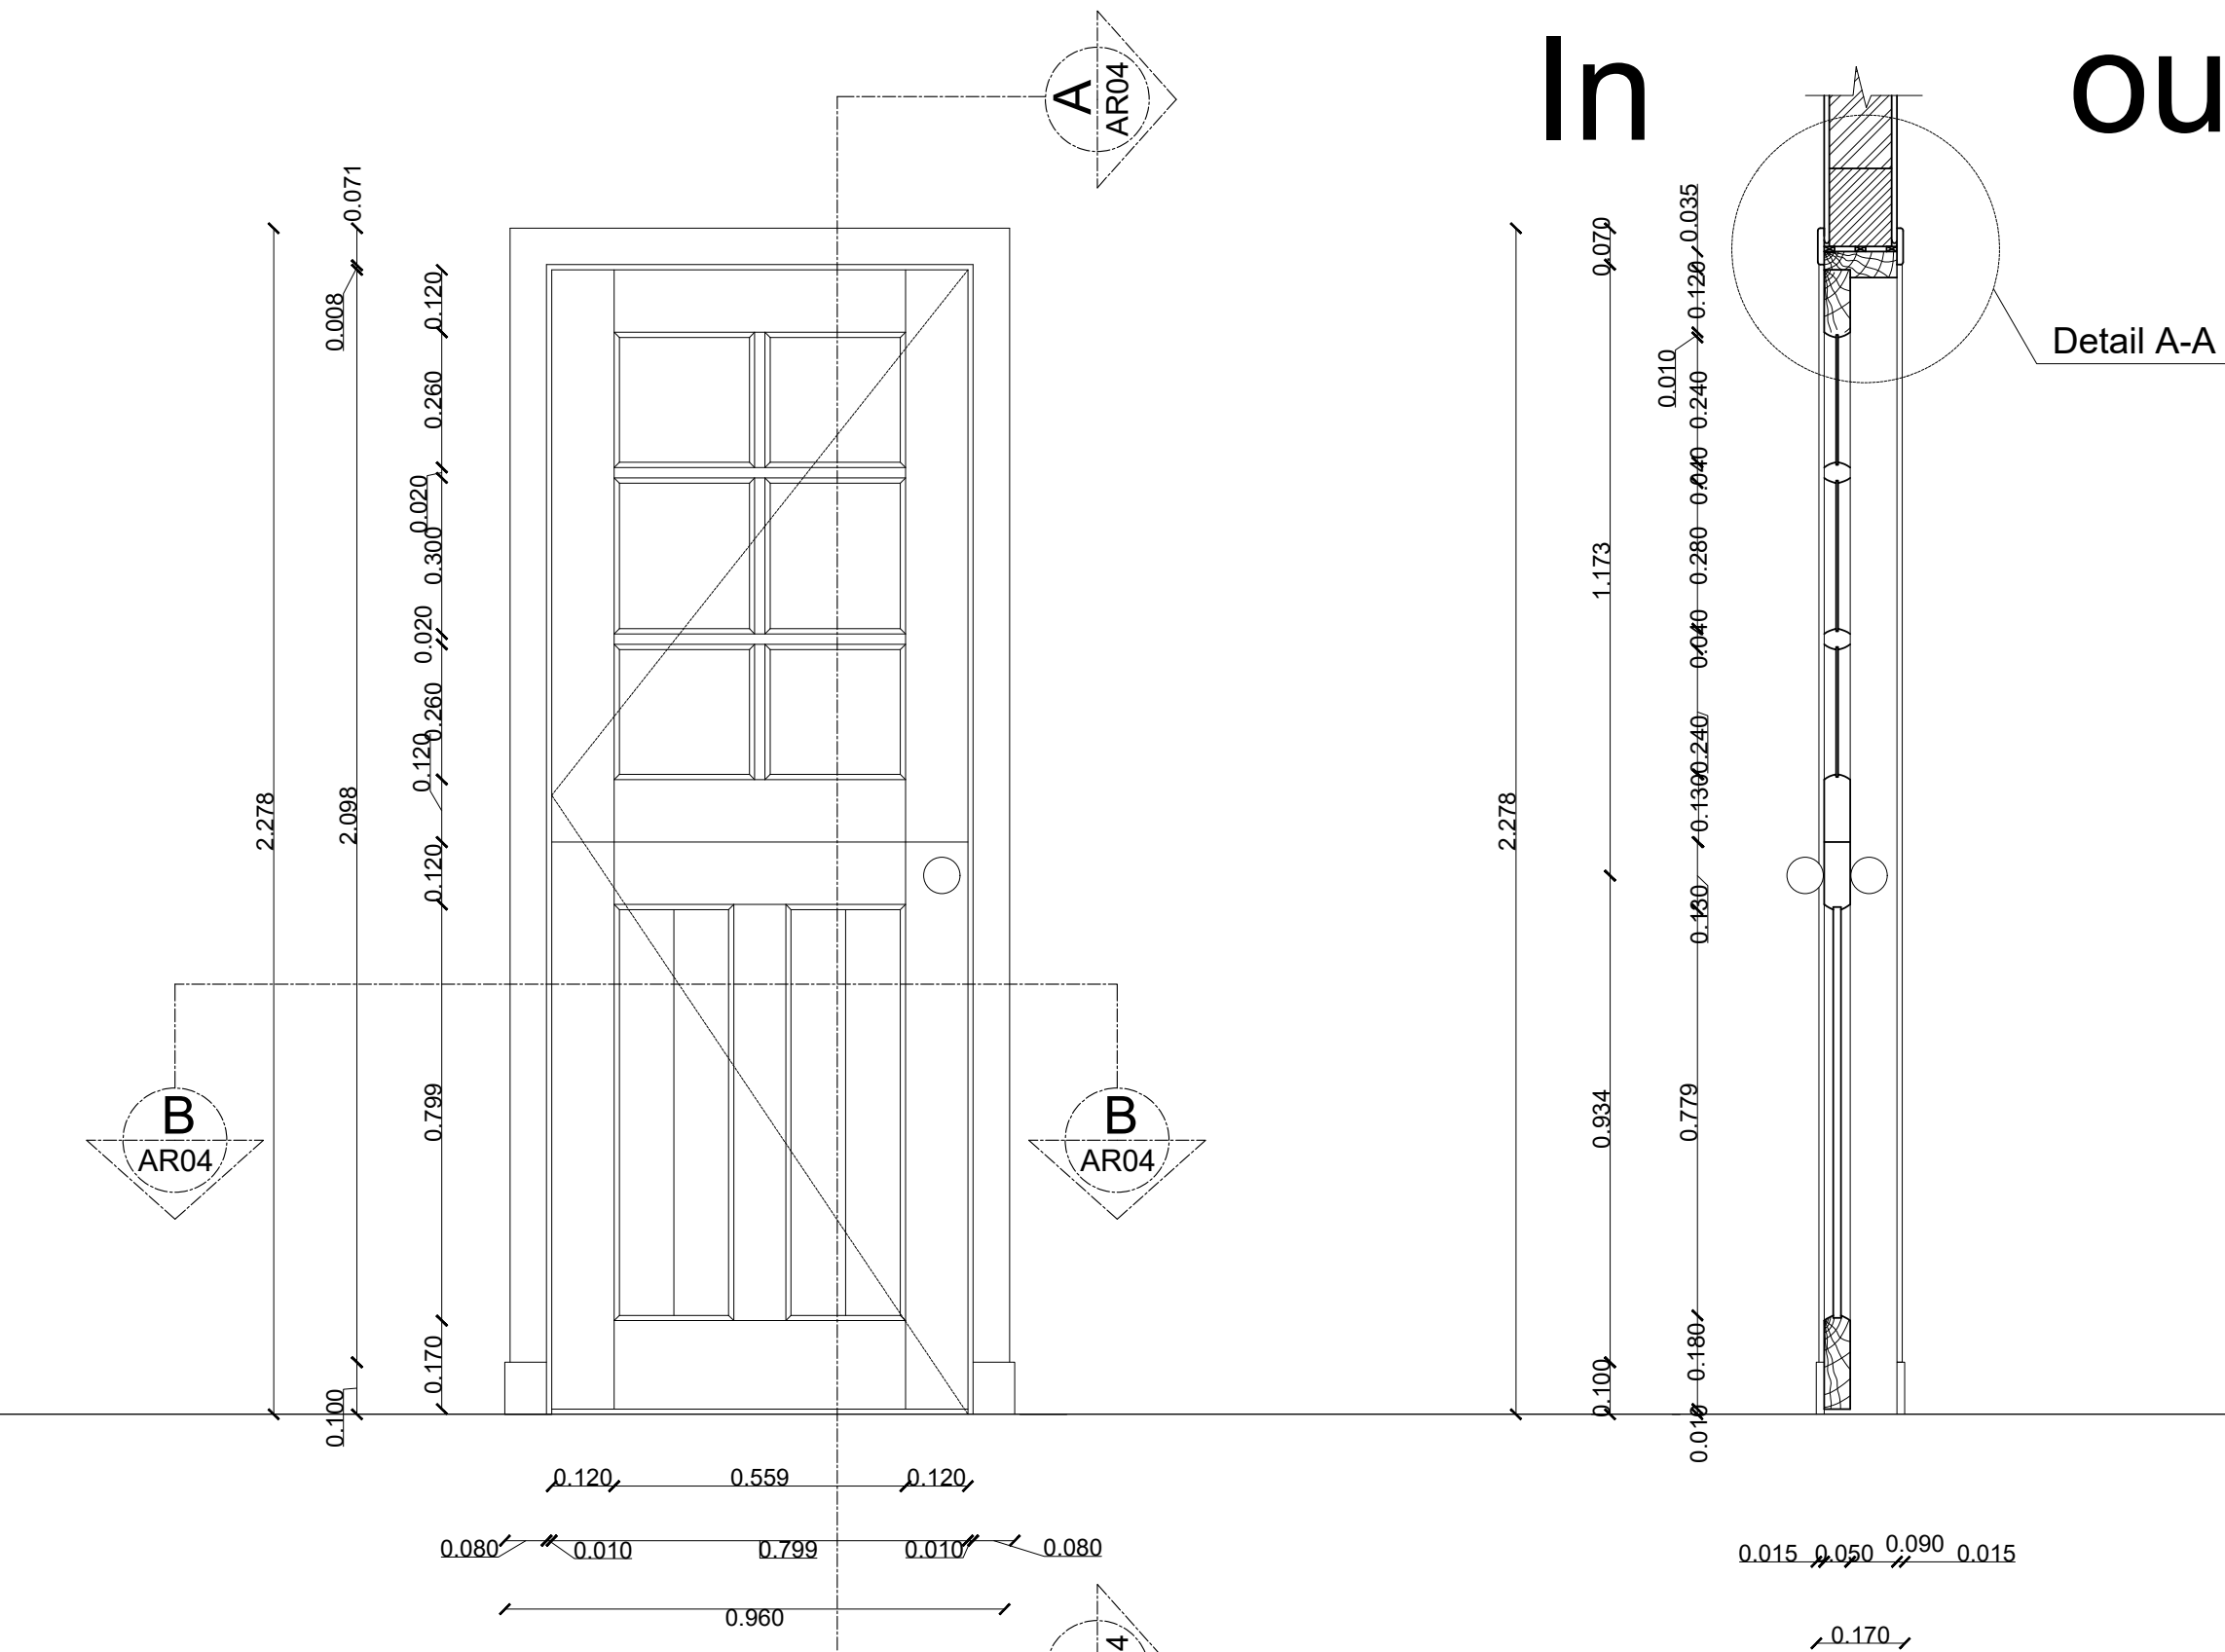


Typical Detail for Wooden Paneled door  
Door Elevation/D1 Scale 1:10

2-A  
AR04


Typical Detail for Wooden Paneled door  
longitudinal section A-A'/D1 Scale 1:10

2-B  
AR04

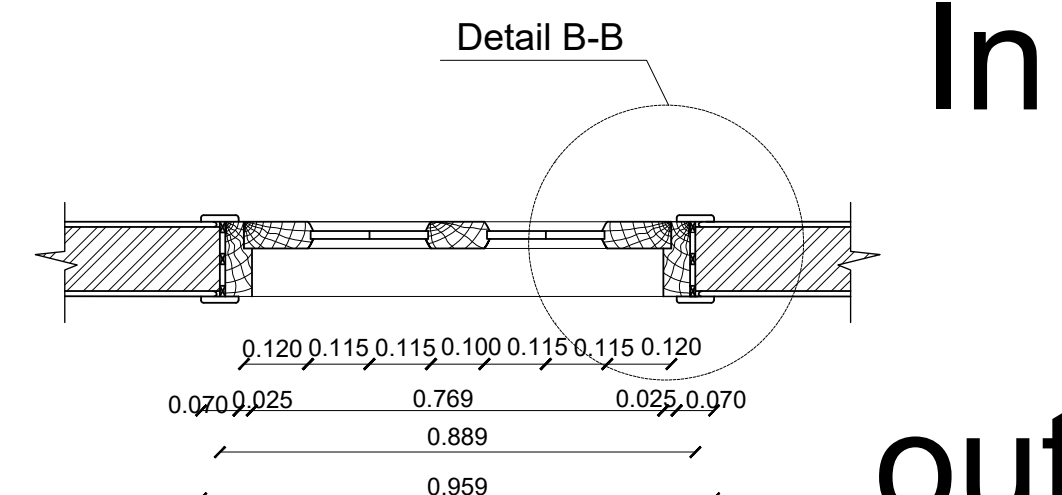


Typical Detail for Wooden Paneled door  
Transferal section B-B'/D1 Scale 1:10

2-C  
AR04

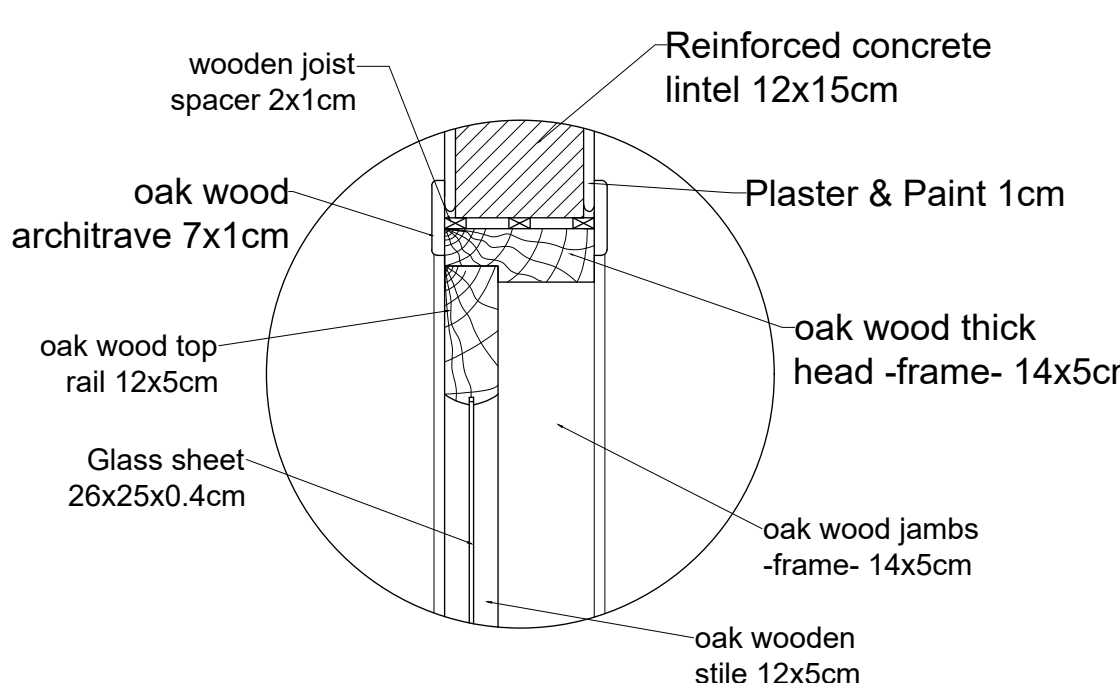



Typical Detail for Wooden Paneled door  
Detail A-A Scale 1:5

2-1  
AR04

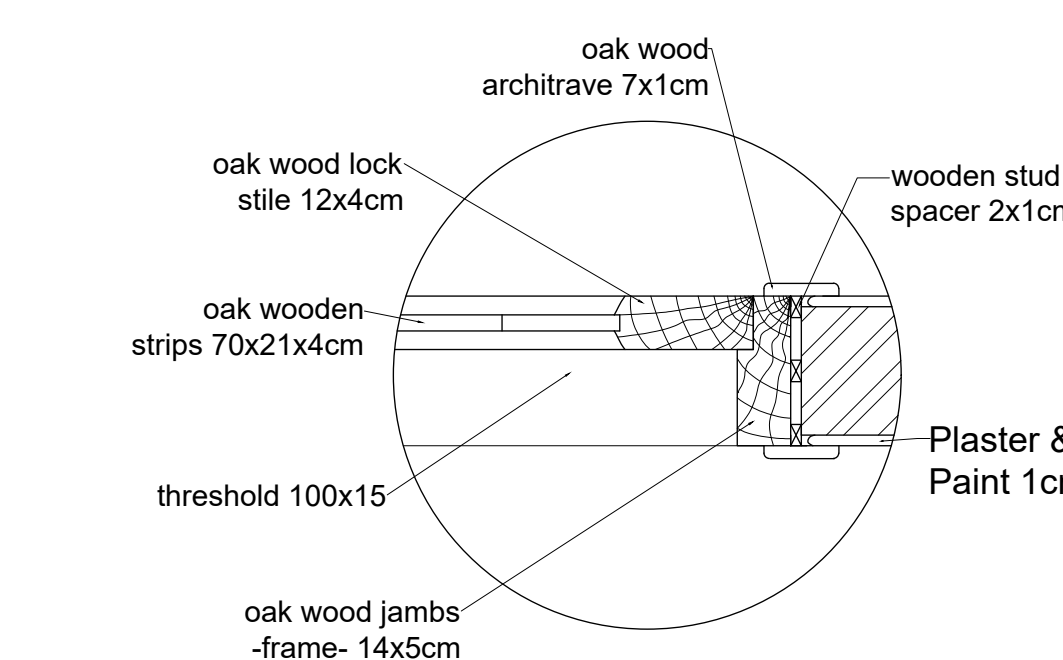


Typical Detail for Wooden Paneled door  
Detail B-B Scale 1:5

2-2  
AR04

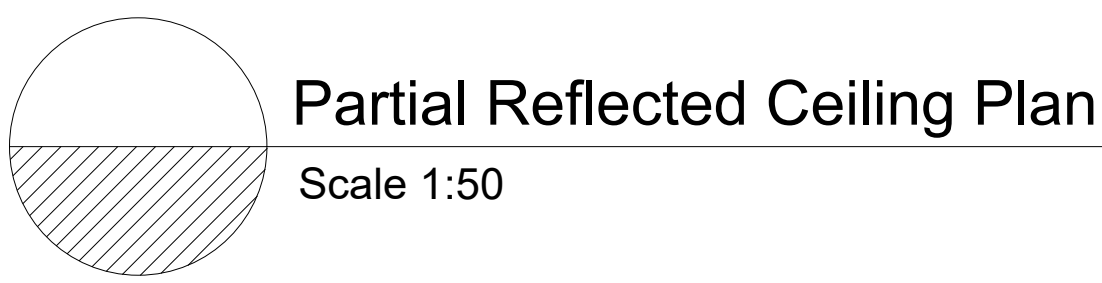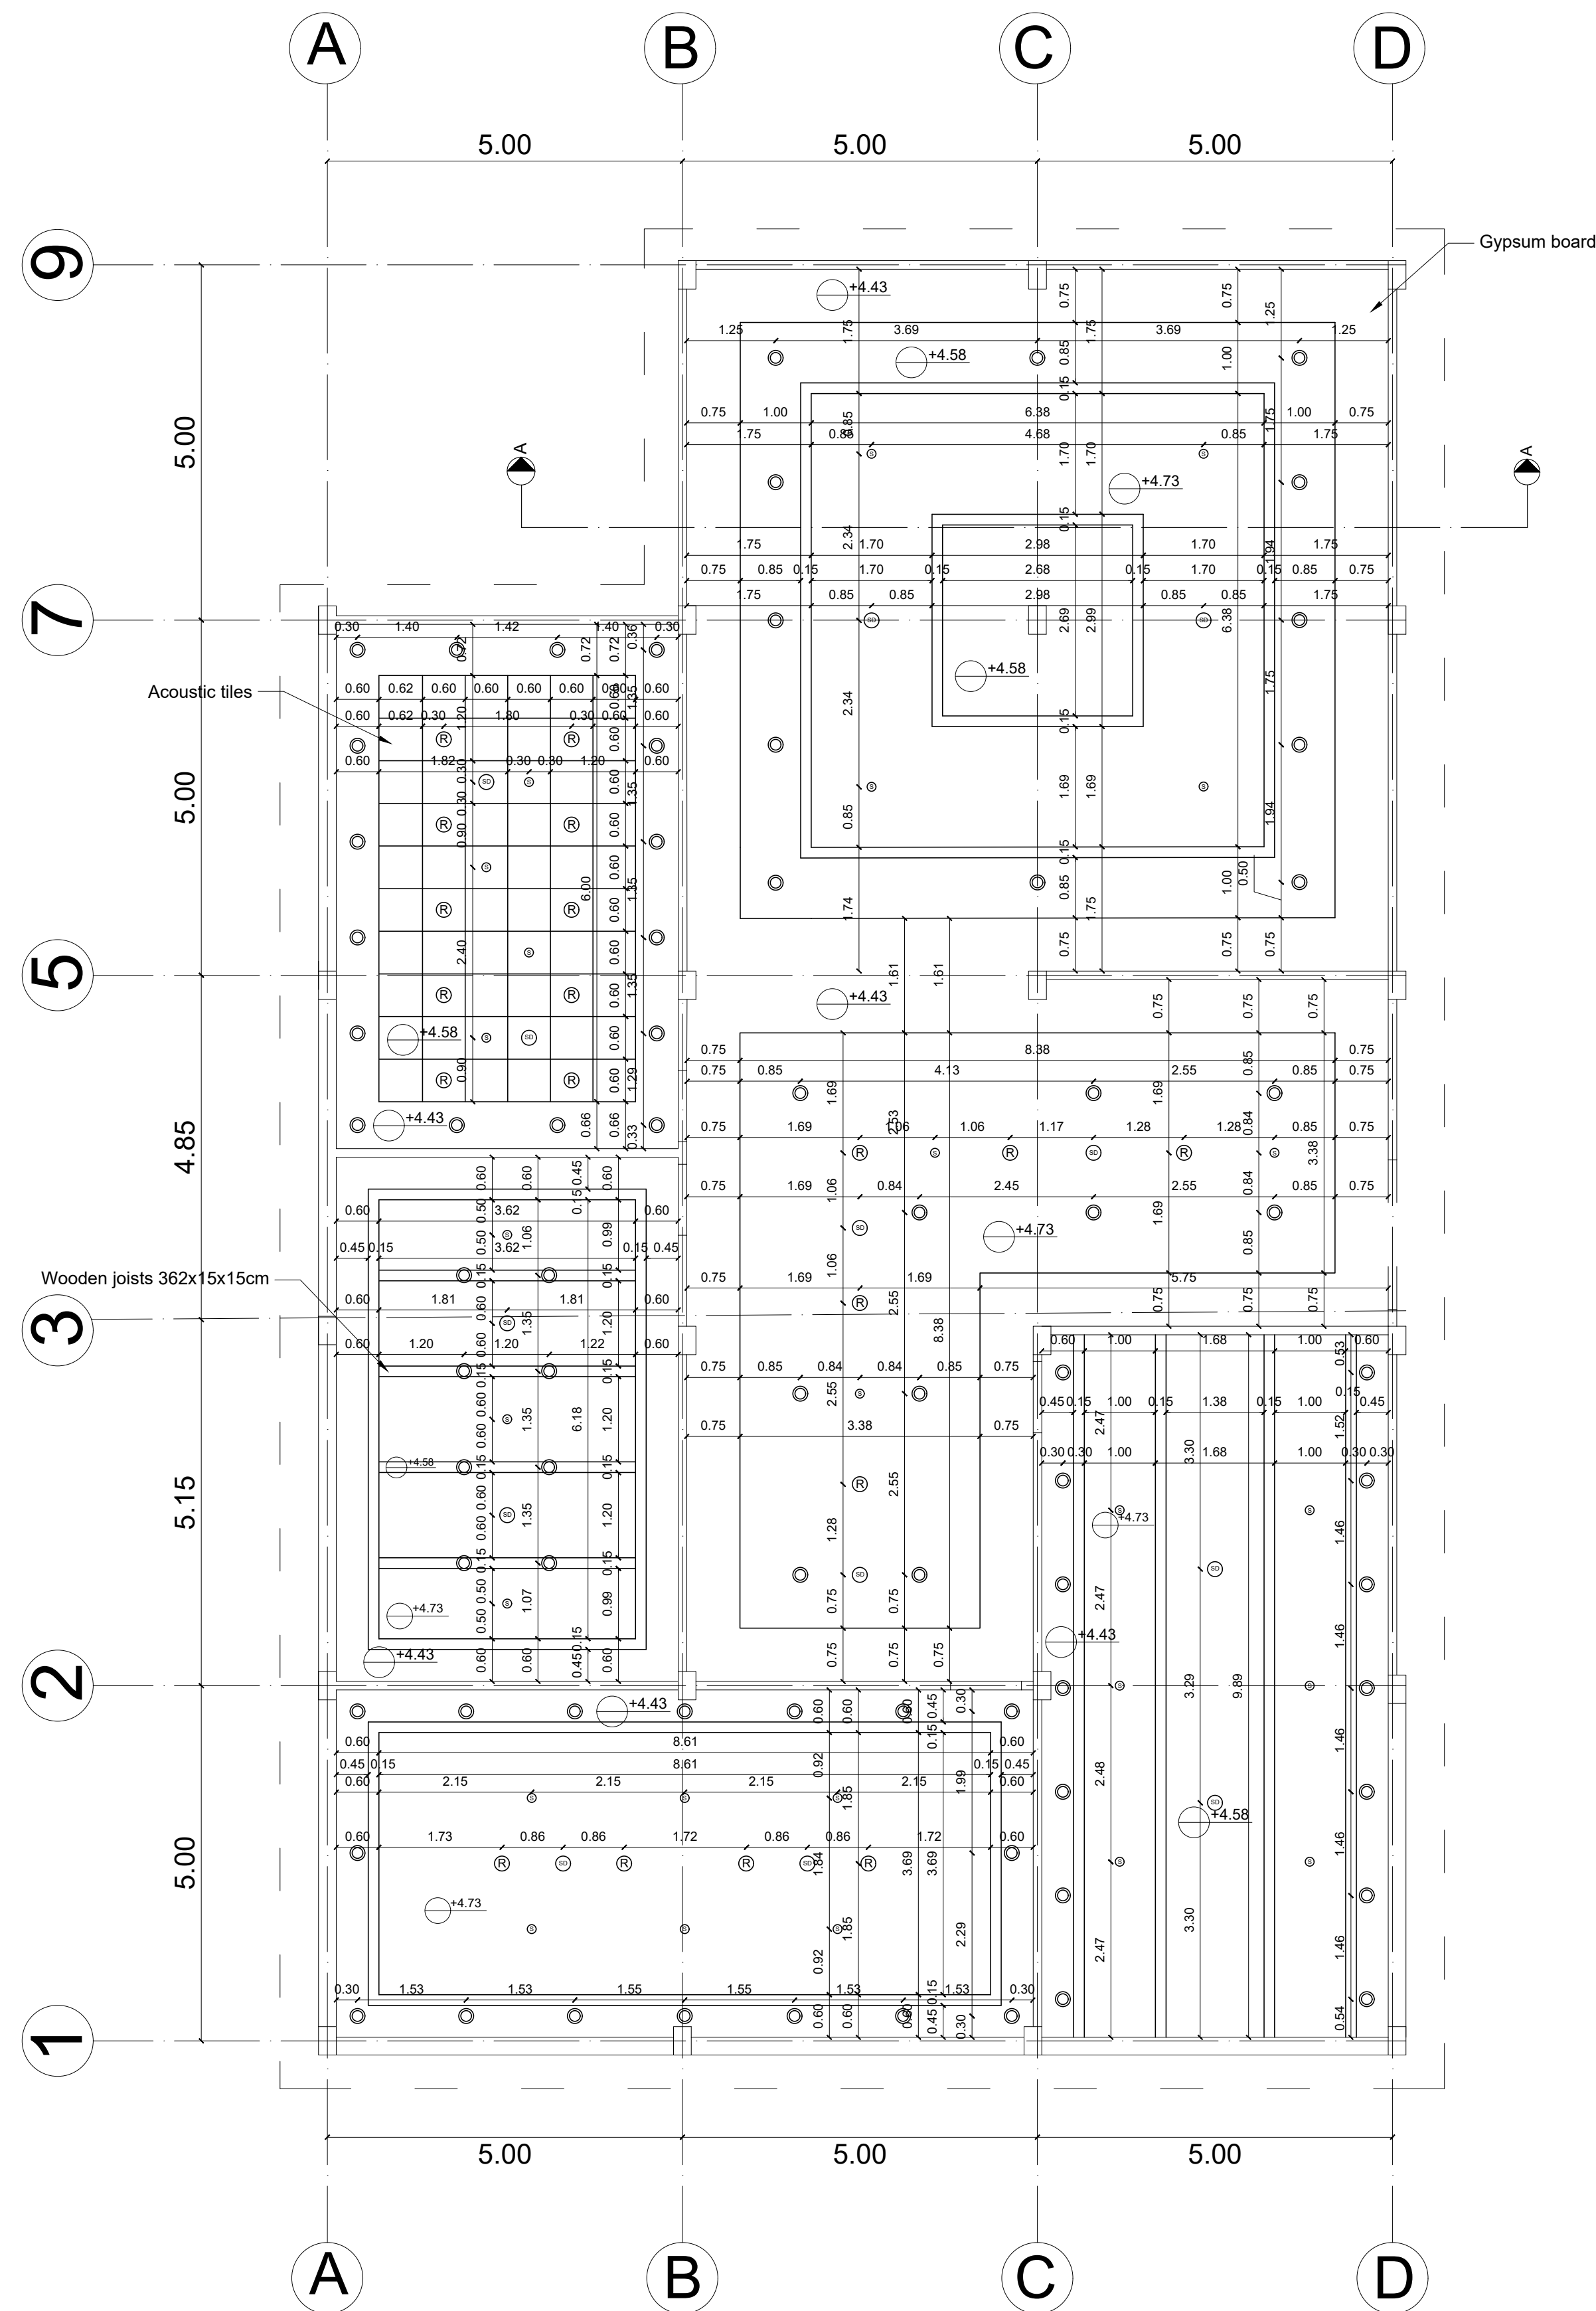

| LEGEND |                                                                                                                                 | LIGHTING LEGEND |          |                    |             |
|--------|---------------------------------------------------------------------------------------------------------------------------------|-----------------|----------|--------------------|-------------|
| SYMBOL | DESCRIPTION                                                                                                                     | WATTS per bulb  | QUANTITY | COLOR              | CODE        |
| (R)    | Recessed LED Downlight, 134x55mm, Aluminum material, LED SMD Samsung 6W, cutout (120mm), 220-240V, Eagle rise, silver casing    | 6W              |          | Pure white (5000K) | 02030245624 |
| (S)    | Recessed LED Spotlight, 86x55mm, Aluminum material, LED COB Samsung 5.4W, cutout (75mm), 220-240V, Eagle rise, silver casing    | 5.4W            |          | Warm white (3000K) | 02030245524 |
| (C)    | Cove light, 5W LED Tube, Aluminum housing, 110x220V, 360mm, 360mm long                                                          | 5W              |          | Warm white (3000K) | RF-0171     |
| (SD)   | Smoke Detector, Sealed lithium battery, photoelectric sensor, Temperature range (4.4-37.8 C), 5.22" in diameter x 1.6" in depth |                 |          |                    | P3010H      |
| (S)    | Fire sprinkler, 56x67mm, coverage area (3m)                                                                                     |                 |          |                    | P3516L      |
| (D)    | Duplex Outlet                                                                                                                   |                 |          |                    |             |
| (F)    | Floor Duplex Outlet                                                                                                             |                 |          |                    |             |
| (S)    | Single Pole Switch                                                                                                              |                 |          |                    |             |
| (D)    | Double Pole Switch                                                                                                              |                 |          |                    |             |
| (T)    | Telephone Outlet                                                                                                                |                 |          |                    |             |

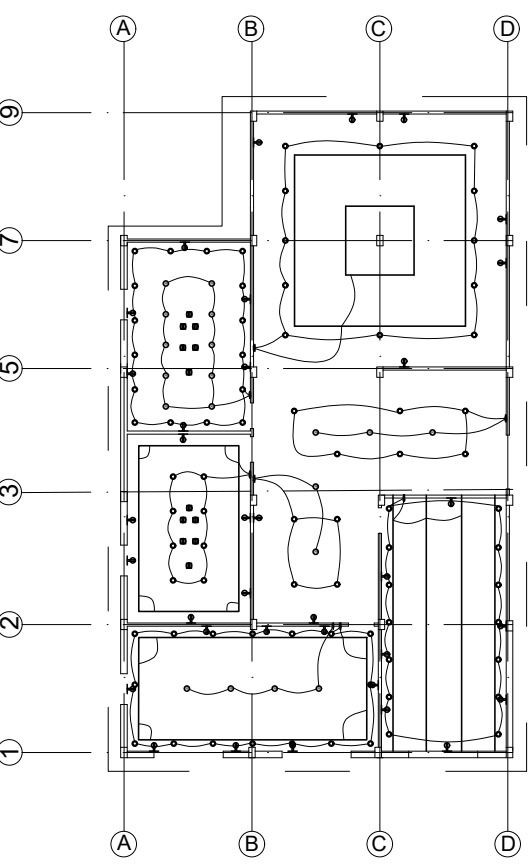

Key Plan: Electrical Partial Plan

Prince Sultan University

Arch & ID Department

Student Activity Center

Working Drawing & Detailing II

ID353

Reflected Ceiling Plan


1:50

AR07

Salam Murad


212410018

Dr. Marwa Fahmi

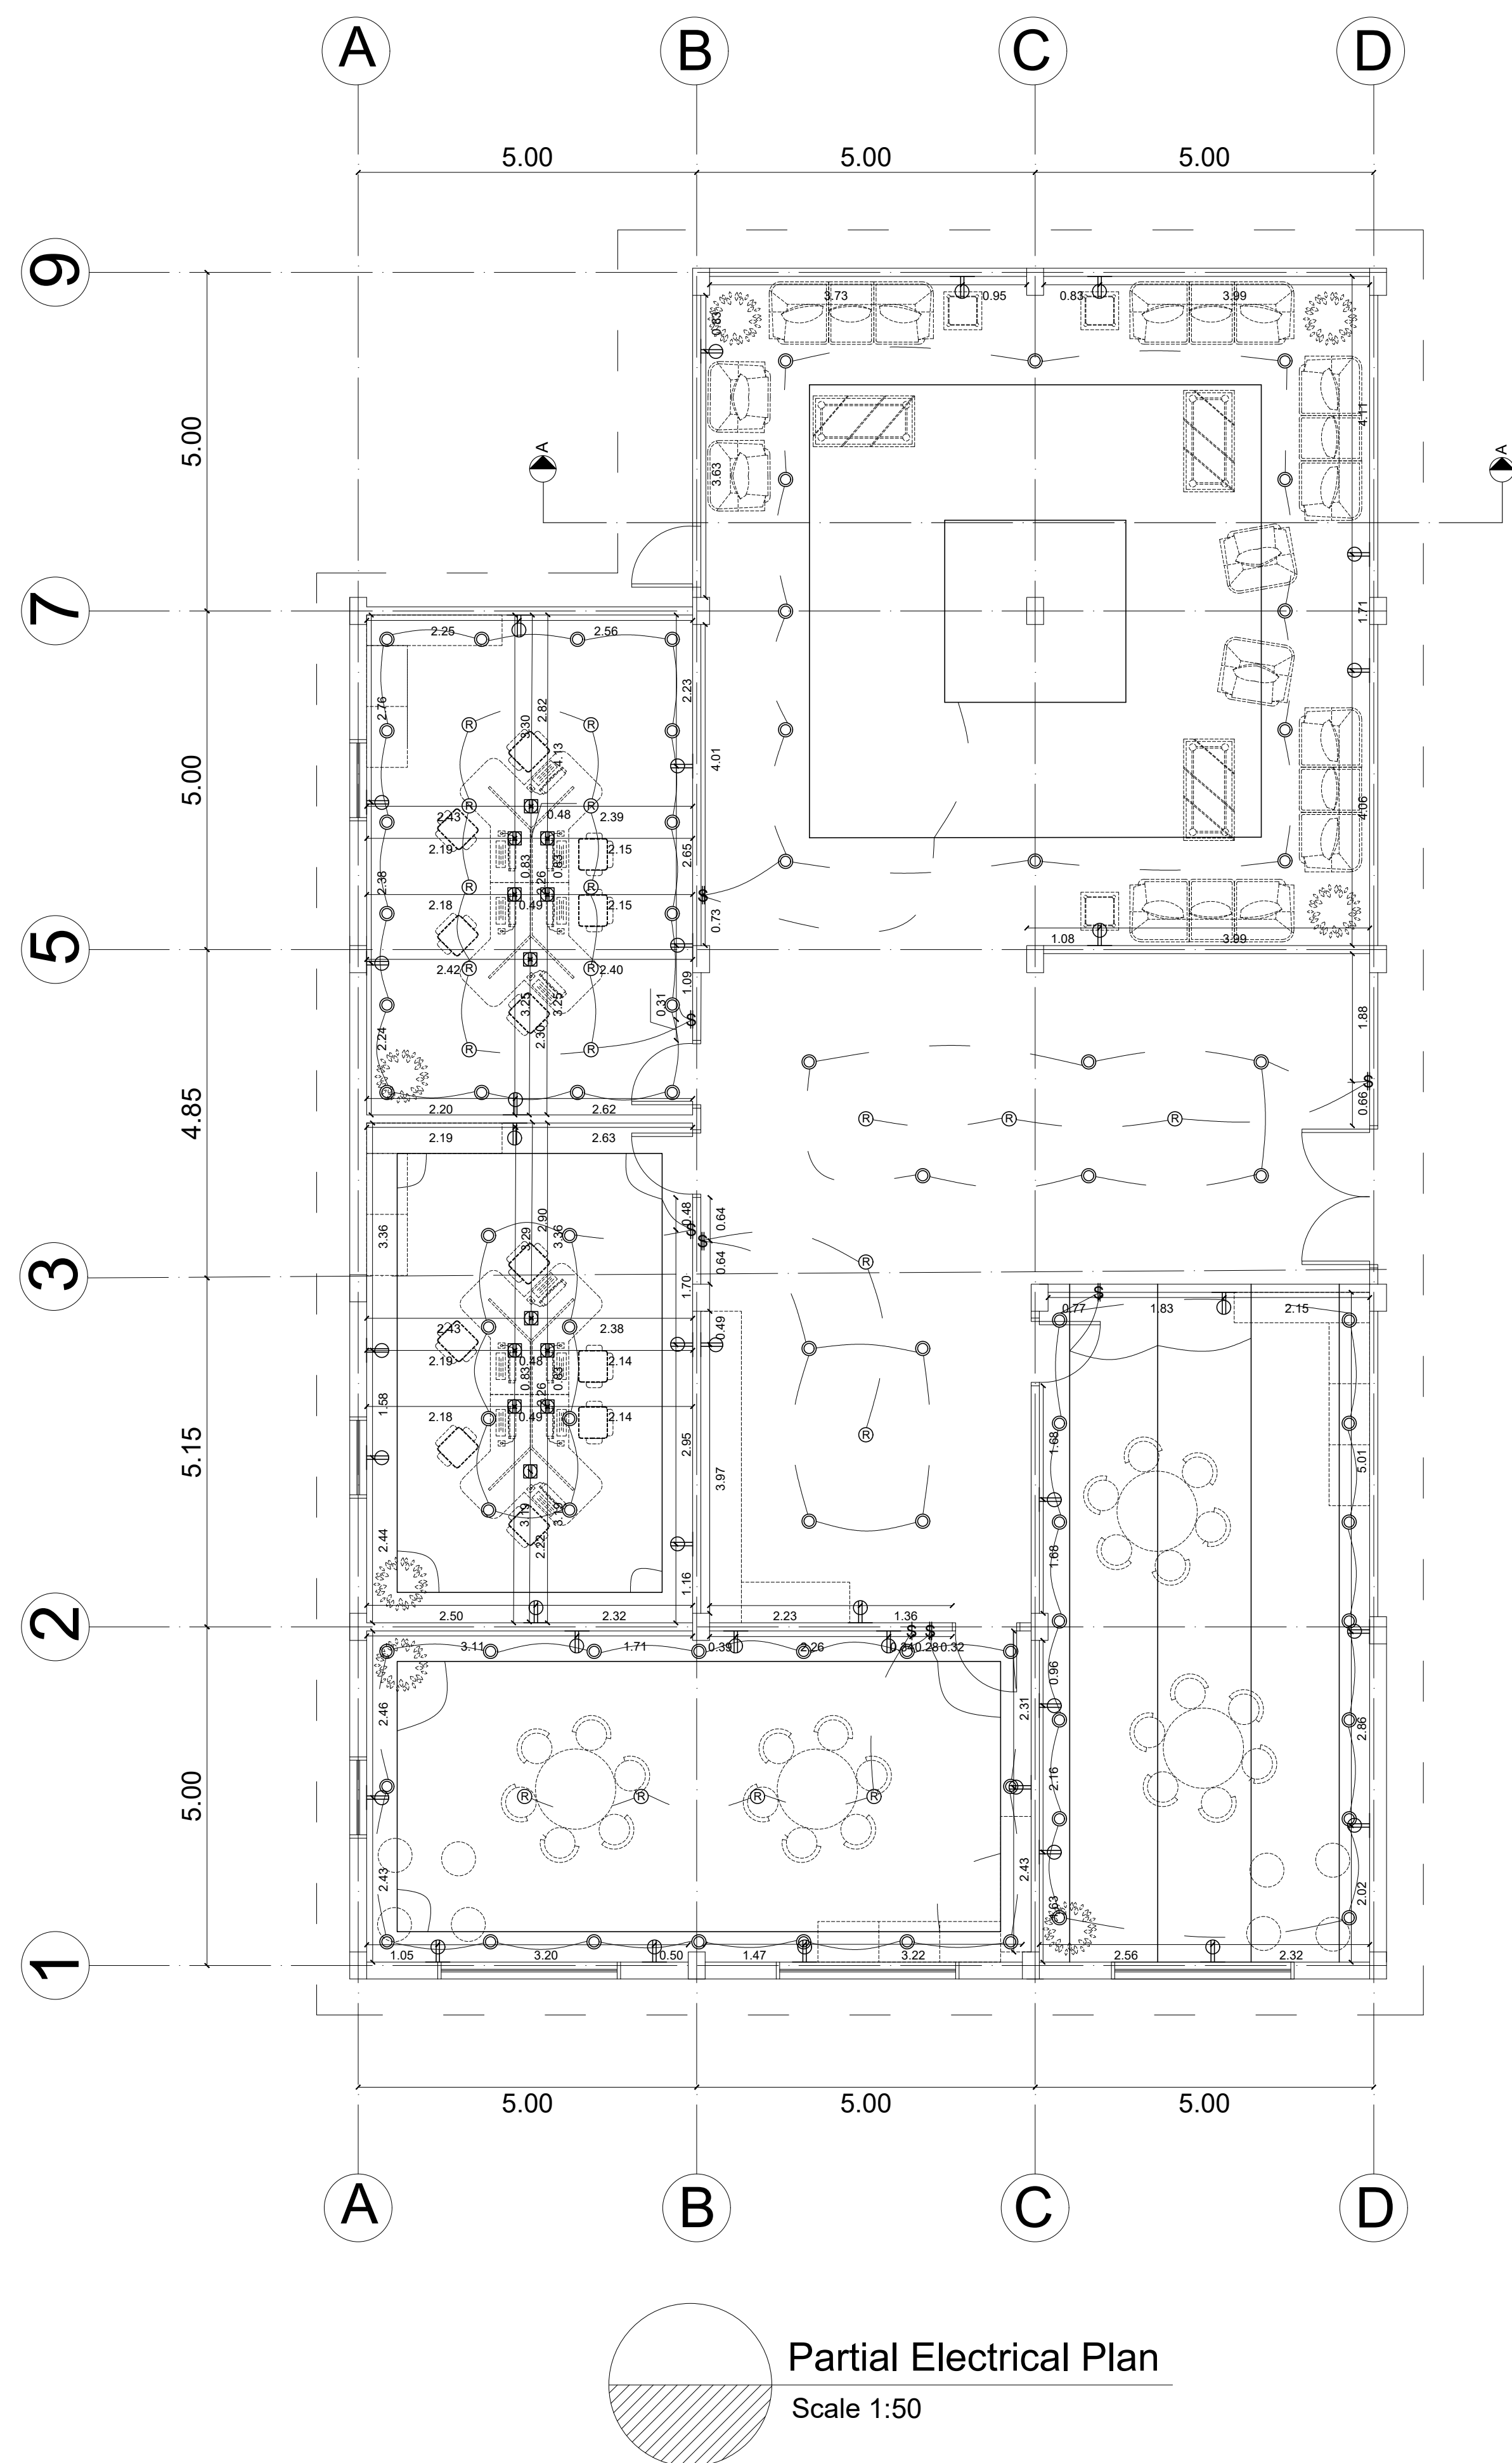

| LEGEND |                                                                                                                                 | LIGHTING LEGEND |          |                    |             |
|--------|---------------------------------------------------------------------------------------------------------------------------------|-----------------|----------|--------------------|-------------|
| SYMBOL | DESCRIPTION                                                                                                                     | WATTS per bulb  | QUANTITY | COLOR              | CODE        |
| (R)    | Recessed LED Downlight, 134x55mm, Aluminum material, LED SMD Samsung 6W, cutout (120mm), 220-240V, Eagle rise, silver casing    | 6W              |          | Pure white (5000K) | 02030245624 |
| (C)    | Recessed LED Spotlight, 86x55mm, Aluminum material, LED COB Samsung 5.4W, cutout (75mm), 220-240V, Eagle rise, silver casing    | 5.4W            |          | Warm white (3000K) | 02030245524 |
|        | Cove light, 5W LED Tube, Aluminum housing, 110-220V, 360lm, 300mm long                                                          | 5W              |          | Warm white (3000K) | RF-0171     |
| (SD)   | Smoke Detector, Sealed lithium battery, photoelectric sensor, Temperature range (4.4-37.8 C), 5.22" in diameter x 1.6" in depth |                 |          |                    | P3010H      |
| (S)    | Fire sprinkler, 56x67mm, coverage area (3m)                                                                                     |                 |          |                    | P3516L      |

| SYMBOL | DESCRIPTION         | NOTES                                                     |
|--------|---------------------|-----------------------------------------------------------|
| (D)    | Duplex Outlet       | All duplex outlets are @45cm from the floor finish        |
| (FD)   | Floor Duplex Outlet |                                                           |
| (S)    | Single Pole Switch  | All single pole switches are @130cm from the floor finish |
| (DS)   | Double Pole Switch  | All double pole switches are @130cm from the floor finish |
| (T)    | Telephone Outlet    | All telephone outlets are @50cm from the floor finish     |

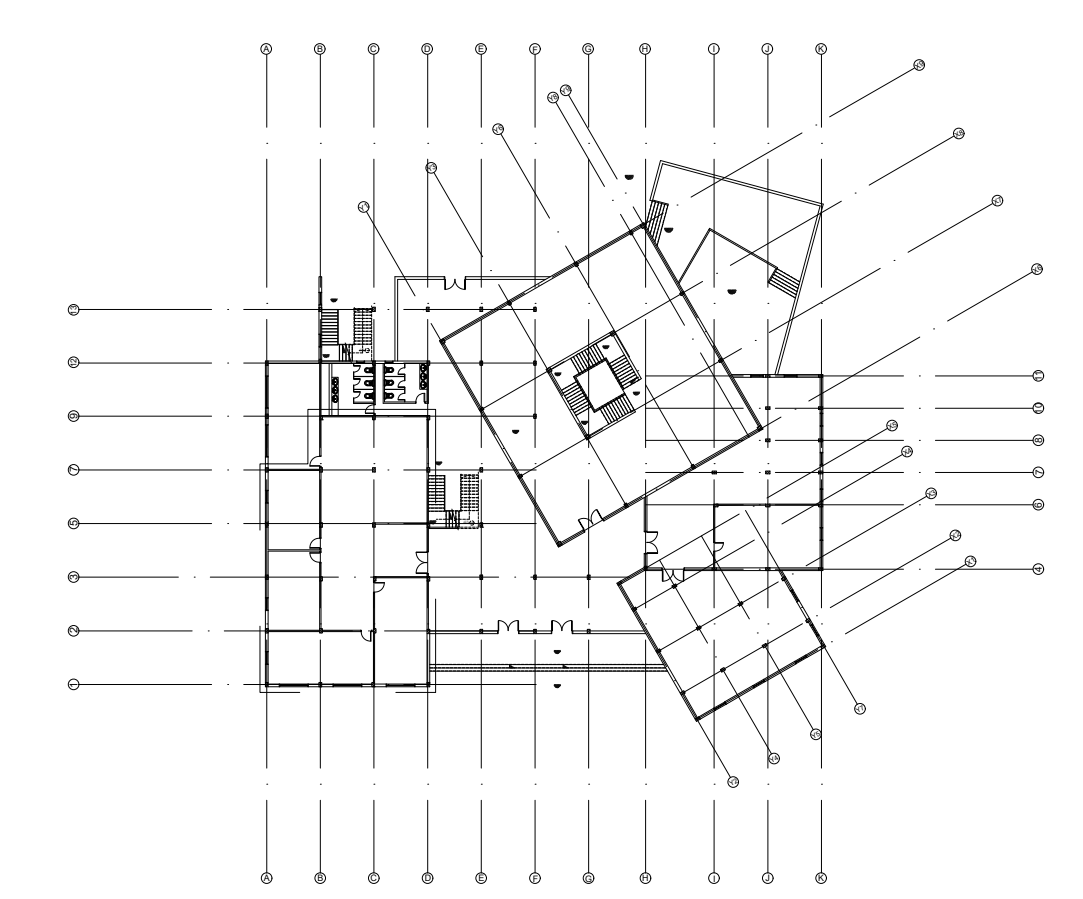

Key plan: Ground Floor Plan

Prince Sultan University

Arch & ID Department

Student Activity Center

Working Drawing & Detailing II

ID353

Electrical Plan



1:50

AR08

Salam Murad


212410018

Dr. Marwa Fahmi

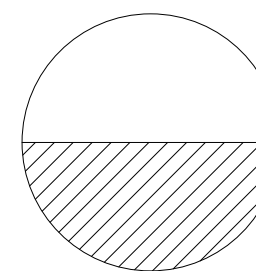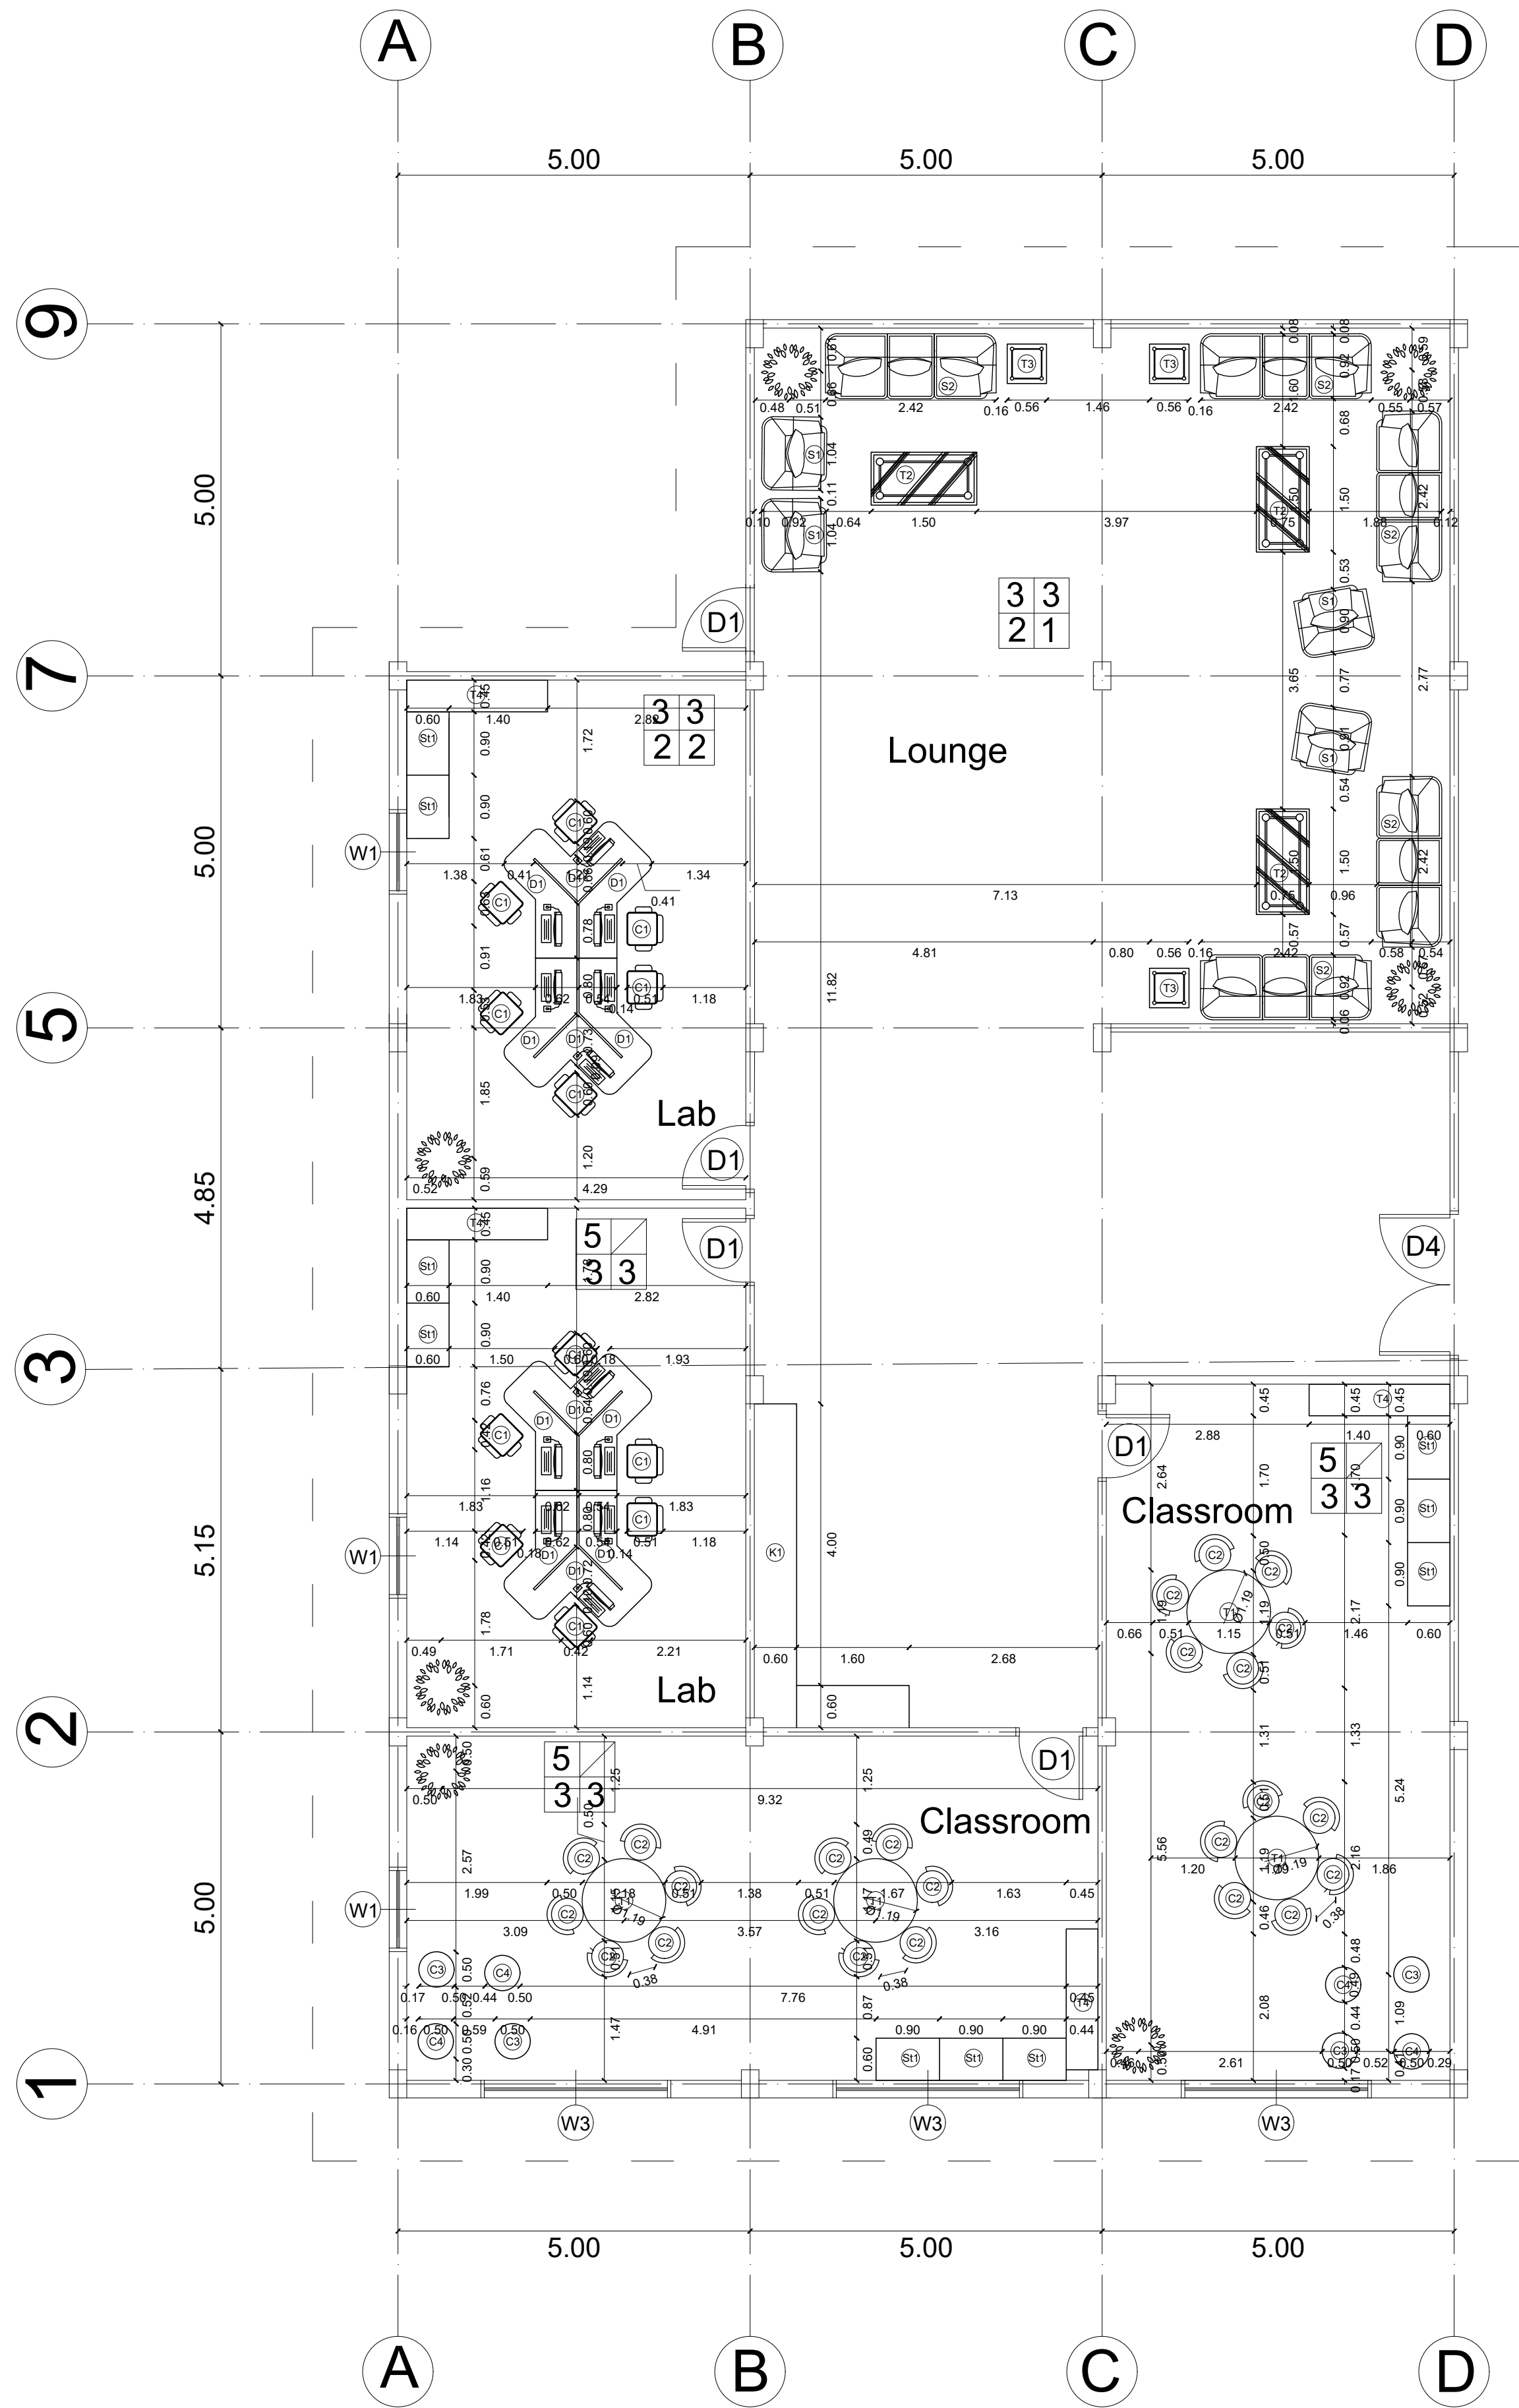

Partial Furniture Plan  
Scale 1:50

| FURNITURE SCHEDULE |      |              |                                                                                                                 |                                                                                       |                                                                                             |
|--------------------|------|--------------|-----------------------------------------------------------------------------------------------------------------|---------------------------------------------------------------------------------------|---------------------------------------------------------------------------------------------|
| SYM.               | QTY. | Manufacturer | Description                                                                                                     | Fabric/Finish                                                                         | Remarks                                                                                     |
| S1                 | 4    | NBF          | modular, light, wooden structure Sofa w27",d29.5",h32.5"                                                        | Finish: Walnut finish Upholstery: Wine fabric                                         | exposed foot and upholstered seating body                                                   |
| S2                 | 5    | NBF          | modular, light, wooden structure Sofa w69.5",d29.5",h32.5"                                                      | Finish: Walnut finish Upholstery: Wine fabric                                         | exposed foot and upholstered seating body                                                   |
| T1                 | 4    | NBF          | Round table, strong laminated top H 29", Diameter 48"                                                           | Finish: Mahogany / Black edge and frame                                               | Exposed brushed chrome table frame                                                          |
| T2                 | 3    | NBF          | Symphony Glass Coffee Table W6",D24",H16"                                                                       | Tempered frosted glass / silver base                                                  | Assembly required, simply attached top                                                      |
| T3                 | 3    | NBF          | Parkside End Table W22", D22", H20"                                                                             | Finish: Tempered frosted glass / silver base                                          | The glass top is easy to clean and adds a sterile look. Some assembly required.             |
| T4                 | 4    | NBF          | Table has clean, uncluttered lines and bold contrasts W72", D20", H30"                                          | Finish: Etched Glass/Brushed Aluminum                                                 | Espresso laminate top over a brushed nickel frame                                           |
| C1                 | 12   | NBF          | Task chair, Mesh Back Chair with Fabric Seat, W27",D27",H40.9"                                                  | Finish: charcoal dove fabric seat/black mesh and frame Upholstery: heavy-duty fabric  | heavy-duty fabric upholstery can withstand constant use                                     |
| C2                 | 24   | NBF          | Armless Ergonomic Task Chair, oversized seat and back to provide exceptional comfort W25.5", D25.5", H34.25-39" | Finish: Gray Fabric/ Black Frame Upholstery: Kalfon Fabric                            | Upholstery is solid. It has a reclining back and adjustable footrest.                       |
| C3                 | 4    | NBF          | Diamond Print Bean Bag, Composition: 100% Polyester W90cm, D52cm, H120cm                                        | Finish: camel/multi Upholstery: polyester                                             | Bean bags are sold unfilled. Composition: 100% Polyester Color: Black/Stone                 |
| C4                 | 4    | NBF          | Diamond Print Bean Bag, Composition: 100% Polyester W90cm, D52cm, H120cm                                        | Finish: camel/multi Upholstery: polyester                                             | Bean bags are sold unfilled. Composition: 100% Polyester Color: Black/Stone                 |
| D1                 | 12   | NBF          | Individual corner workstation, fabric-covered desktop screen, W27", D27", H42"                                  | Finish: Black finish / Veil fabric laminate Mahogany laminate top and 1/4" solid edge | The three-drawer pedestal is made out of heavy-gauge steel                                  |
| St1                | 10   | NBF          | Work storage cabinet with wooden doors W36.25, D18.25, H24.25                                                   | Finish: Espresso Wenge / Brushed Nickel Handles                                       | This storage cabinet can be stacked on top of the matching A1 Work Collection lateral file. |
| K1                 | 1    | NBF          | Kitchen counter, Tablet project plays with the aesthetics                                                       | Finish: oak painted with white & red                                                  | natural oak drawers and compartment with glossy lacquered parts in white.                   |

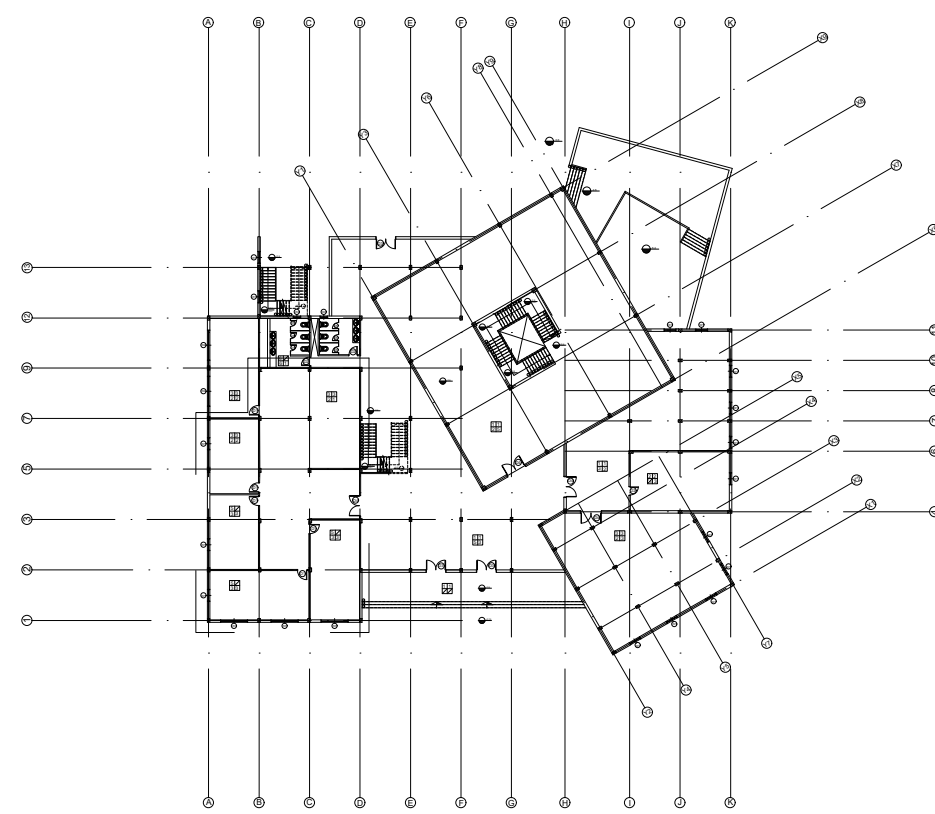

Key plan: Ground Floor Plan

Prince Sultan University

Arch & ID Department

Student Activity Center

Working Drawing & Detailing II

ID353

Furniture Plan


1:50

AR09

Salam Murad


212410018

Dr. Marwa Fahmi

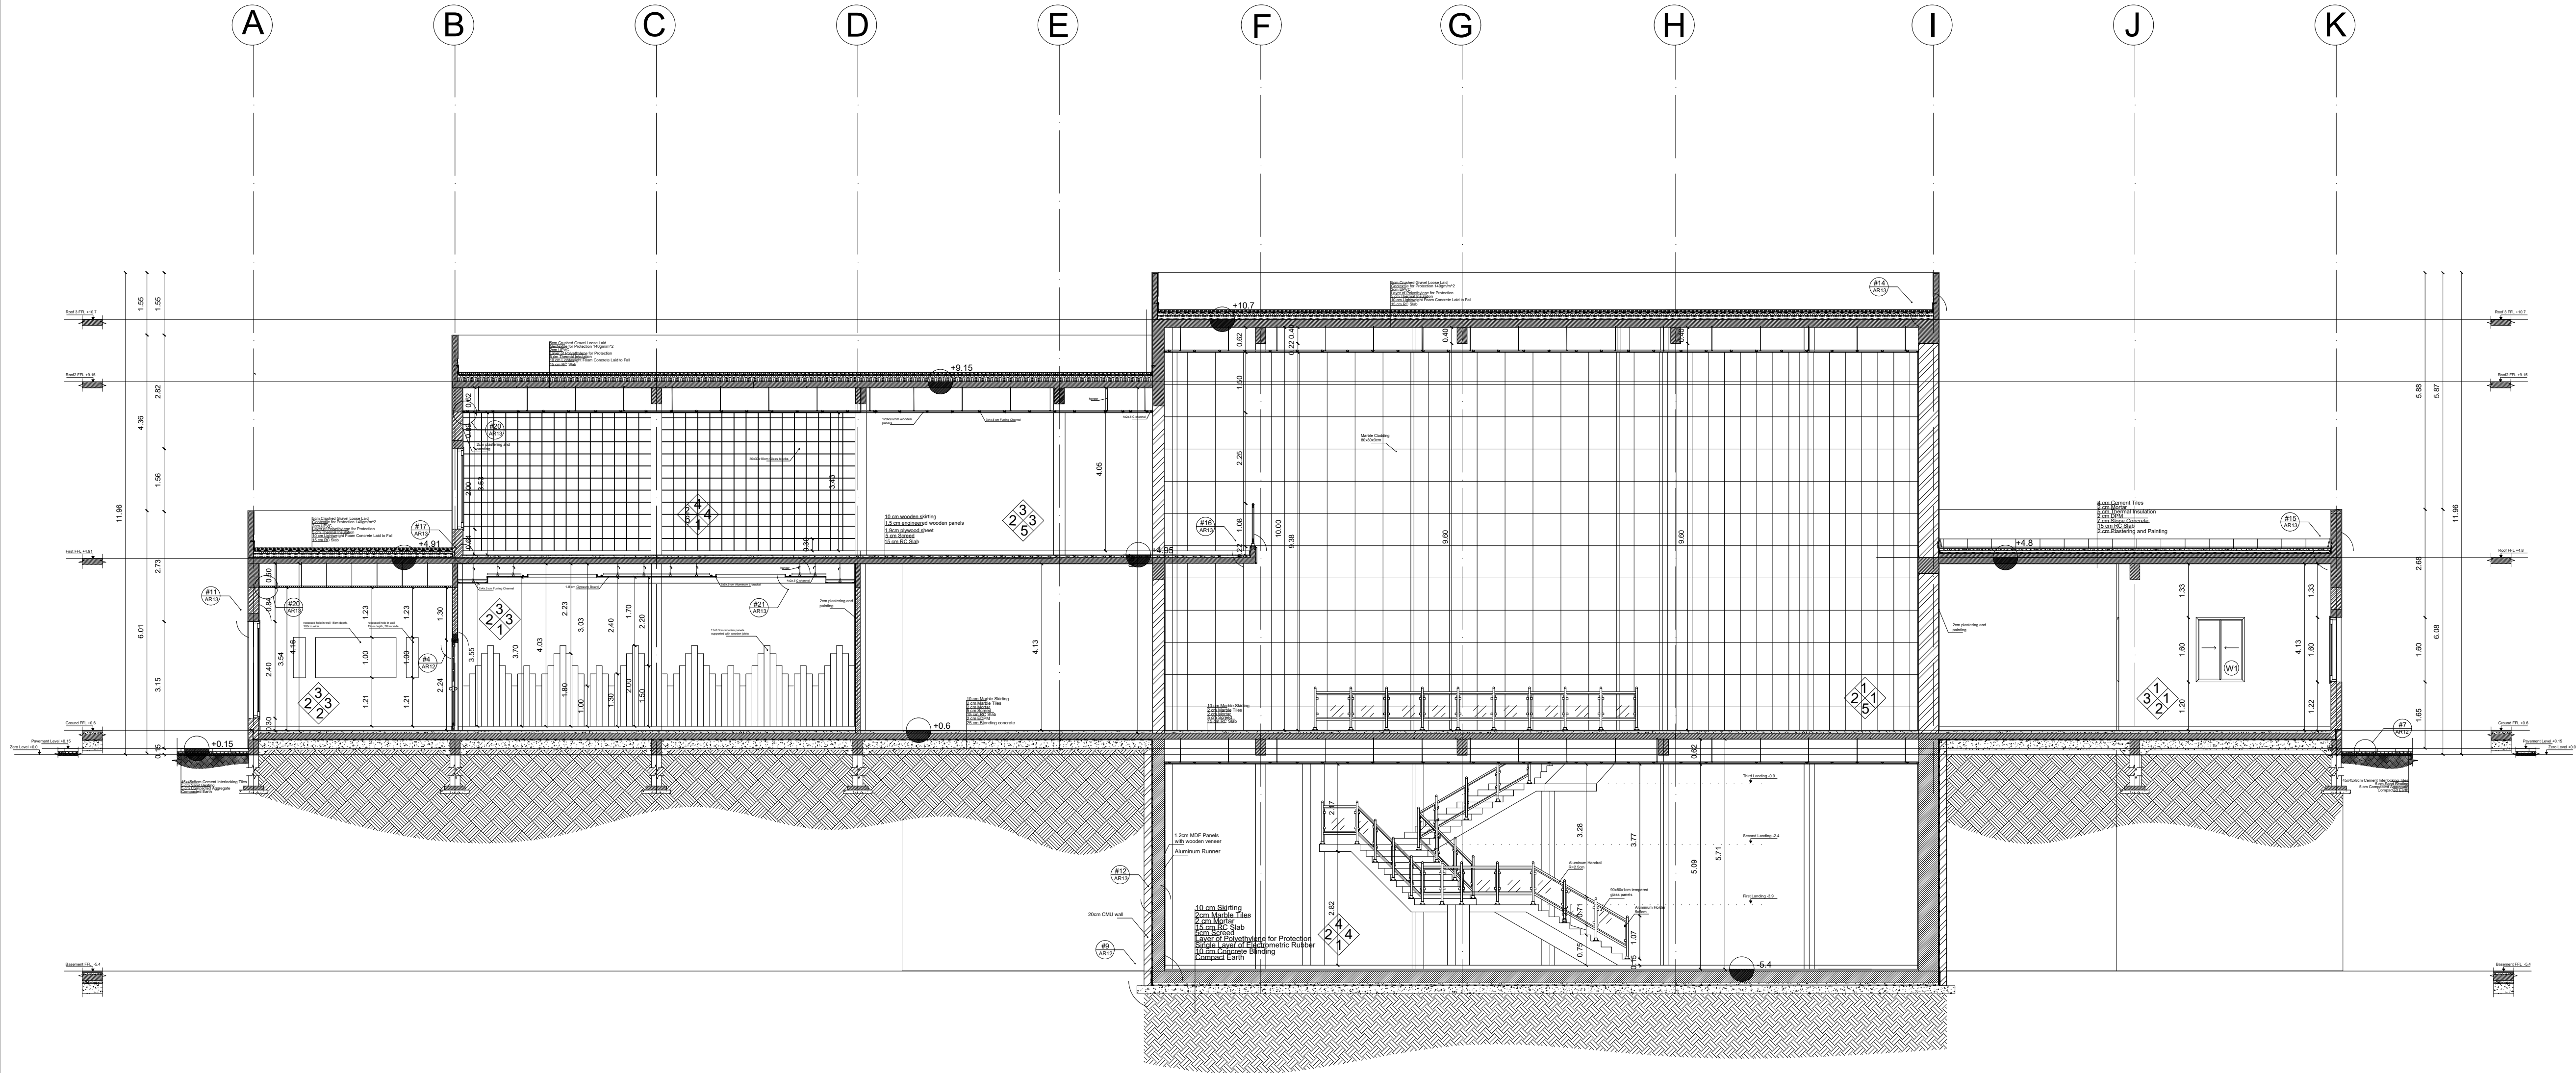

| WINDOWS SCHEDULES |            |       |        |       |           |                  |                          |         |  |  |
|-------------------|------------|-------|--------|-------|-----------|------------------|--------------------------|---------|--|--|
| SYM               | DIMENSIONS | Frame | SILL   | TYPE  | OPERATION | MATERIAL         | DESCRIPTION              | Elev.   |  |  |
| W1                | 1.2 m      | 1.6 m | 0.05 m | 0.9 m | Casement  | Double Side Hung | Glazed Double Glazed     | Elev 1  |  |  |
| W2                | 3 m        | 2.4 m | 0.05 m | 0.3 m | Casement  | Double Side Hung | Glazed Double Glazed     | Elev 2  |  |  |
| W3                | 2.7 m      | 2.4 m | 0.05 m | 0.3 m | Casement  | Double Side Hung | Glazed Translucent Glass | Elev 3  |  |  |
| W4                | 0.75 m     | 0.6 m | 0.05 m | 1.5 m | Casement  | Top Hung         | Glazed Translucent Glass | Elev 4  |  |  |
| W5                | 2 m        | 1.2 m | 0.05 m | 1.2 m | Casement  | Double Side Hung | Glazed Double Glazed     | Elev 5  |  |  |
| W6                | 4.06 m     | 2 m   | 0.05 m | 0.7 m | Casement  | Top Hung         | Glazed Double Glazed     | Elev 6  |  |  |
| W7                | 4.34 m     | 2 m   | 0.05 m | 0.7 m | Casement  | Top Hung         | Glazed Double Glazed     | Elev 7  |  |  |
| W8                | 4.29 m     | 2 m   | 0.05 m | 0.7 m | Casement  | Top Hung         | Glazed Double Glazed     | Elev 8  |  |  |
| W9                | 4.42 m     | 2 m   | 0.05 m | 0.7 m | Casement  | Top Hung         | Glazed Double Glazed     | Elev 9  |  |  |
| W10               | 3.6 m      | 2 m   | 0.05 m | 0.7 m | Casement  | Top Hung         | Glazed Double Glazed     | Elev 10 |  |  |

| DOORS SCHEDULES |            |       |           |        |            |              |             |        |  |  |
|-----------------|------------|-------|-----------|--------|------------|--------------|-------------|--------|--|--|
| SYM             | DIMENSIONS | Frame | THICKNESS | TYPE   | OPERATION  | MATERIAL     | DESCRIPTION | Elev.  |  |  |
| D1              | 1 m        | 3 m   | 0.05 m    | 0.12 m | paneled    | 1 Side Swing | Wood        | Elev 3 |  |  |
| D2              | 0.9 m      | 2.2 m | 0.05 m    | 0.12 m | Flush Door | 1 Side Swing | Wood        | Elev 4 |  |  |
| D3              | 2 m        | 2.2 m | 0.05 m    | 0.25 m | Flush Door | 2 Side Swing | Wood        | Elev 1 |  |  |
| D4              | 2.1 m      | 2.2 m | 0.05 m    | 0.12 m | paneled    | 2 Side Swing | Wood        | Elev 2 |  |  |
| D5              | 0.75 m     | 3 m   | 0.05 m    | 0.02 m | Flush Door | 1 Side Swing | Phenolic    | Elev 5 |  |  |

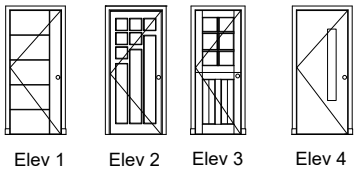


| Flooring |                  |                                                                                                          | Dimensions     |
|----------|------------------|----------------------------------------------------------------------------------------------------------|----------------|
| NO       | Materials        | Description                                                                                              |                |
| 1        | Marble           | Light beige Tuscan Cream marble & polished, shiny and glossy finish. Installed with cement mortar.       | 80x80x2 cm     |
| 2        | Wooden Parquet   | White oak plysueum wooden parquet, thermophone style. Solid wood.                                        | 120x60x1.5 cm  |
| 3        | Wooden strips    | Hard wood flooring-Hickory Backsated Brown wood. Installed on wooden joints and staggered.               | 240x100x1.8 cm |
| 4        | Transverse tiles | Brush Light Walnut finished transverse floor tile.                                                       | 80x80x2 cm     |
| 5        | Tiles            | Heatreflect Tiles- 10x8 Tiles vinyl, low gloss finish. Installed with an adhesive.                       | 75x75x0.15 cm  |
| 6        | Ceramic Tiles    | Copper and silver mosaic tile, 20x20x0.5 cm. Installed on a prepared surface the shiny finished side up. | 20x20x0.5 cm   |


| Skirting  |                  |                                                                                                    | Dimensions     |
|-----------|------------------|----------------------------------------------------------------------------------------------------|----------------|
| Materials | Description      |                                                                                                    |                |
| 1         | Marble           | Light beige Tuscan Cream marble & polished, shiny and glossy finish. Installed with cement mortar. | 80x100x2 cm    |
| 2         | Wooden Parquet   | White oak plysueum wooden parquet, thermophone style. Solid wood.                                  | 120x60x1.5 cm  |
| 3         | Wooden strips    | Hard wood flooring-Hickory Backsated Brown wood. Installed on wooden joints and staggered.         | 240x100x1.8 cm |
| 4         | Transverse tiles | Brush Light Walnut finished transverse floor tile.                                                 | 80x80x2 cm     |

| Walls     |             |                                                                                                     | Dimensions    |
|-----------|-------------|-----------------------------------------------------------------------------------------------------|---------------|
| Materials | Description |                                                                                                     |               |
| 1         | Paint       | White Durable Matt Emulsion Paint Becoat Crown                                                      |               |
| 2         | Paint 2     | White Durable Semi Gloss Emulsion Paint Magnolia                                                    |               |
| 3         | Wall Paper  | Silver Stripe red model for the east wall                                                           |               |
| 4         | Wood        | DKL Tannan oak finished timber with reddish brown finish                                            | 120x15x1.5 cm |
| 5         | Marble      | Dark grey marble with 2 mm deep, shiny and glossy finish. Installed with horizontal aluminum rails. | 30x60x1.5 cm  |
| 6         | Ceramic     | Monocolor Solid 50x50 mm tiles, glossy and finished with a wet-lay.                                 | 50x50x0.8 cm  |


| Ceiling   |               |                                                                                              | Dimensions    |
|-----------|---------------|----------------------------------------------------------------------------------------------|---------------|
| Materials | Description   |                                                                                              |               |
| 1         | Paint         | creamy color with semi-gloss finish                                                          |               |
| 2         | Acoustic      | white non-reflecting ceiling diffusers interior                                              | 600X60X1.2 cm |
| 3         | Gypsum        | white non-reflecting                                                                         | 600X60X2 cm   |
| 4         | Plaster board | white non-reflecting Per Ceiling Cadding interior                                            | 300x60x2 cm   |
| 5         | Wood          | white oak veneer panels mounted to redwood wood batten. The panels laminated with HD V-Glad. | 120x60x2 cm   |

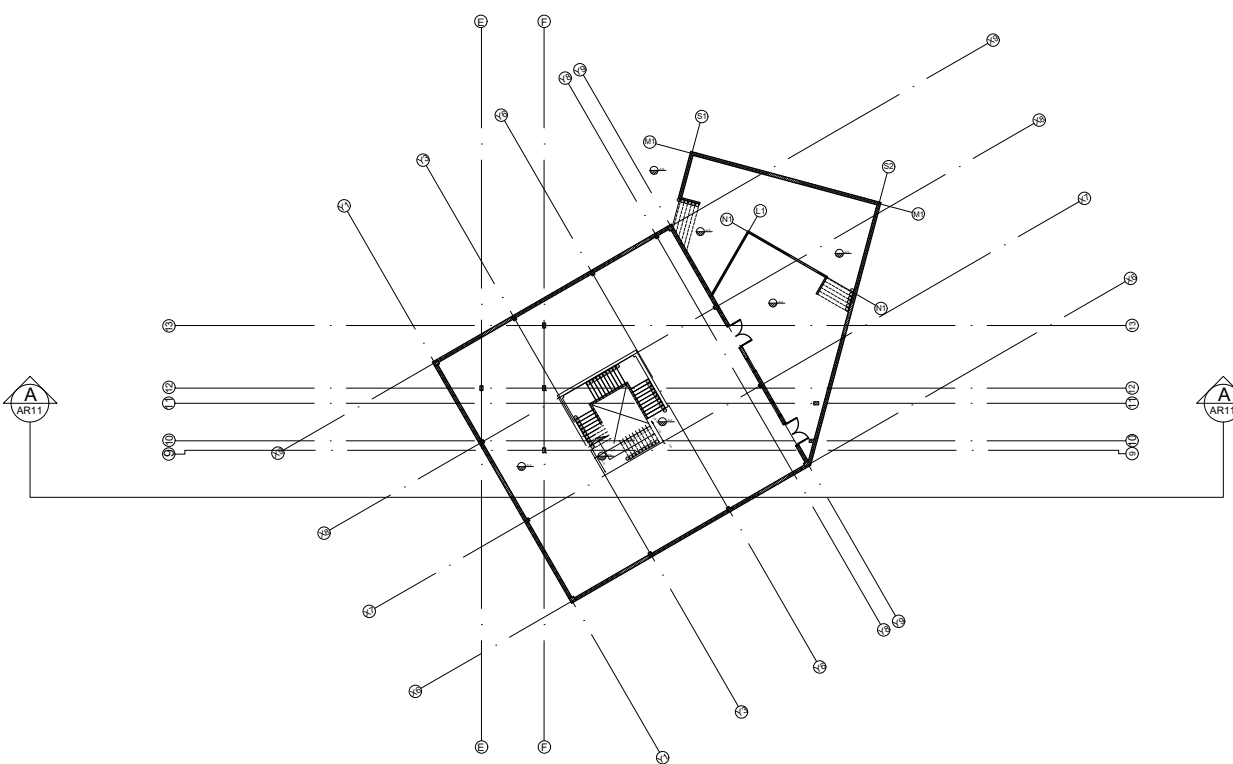

Key plan: Basement Floor Plan

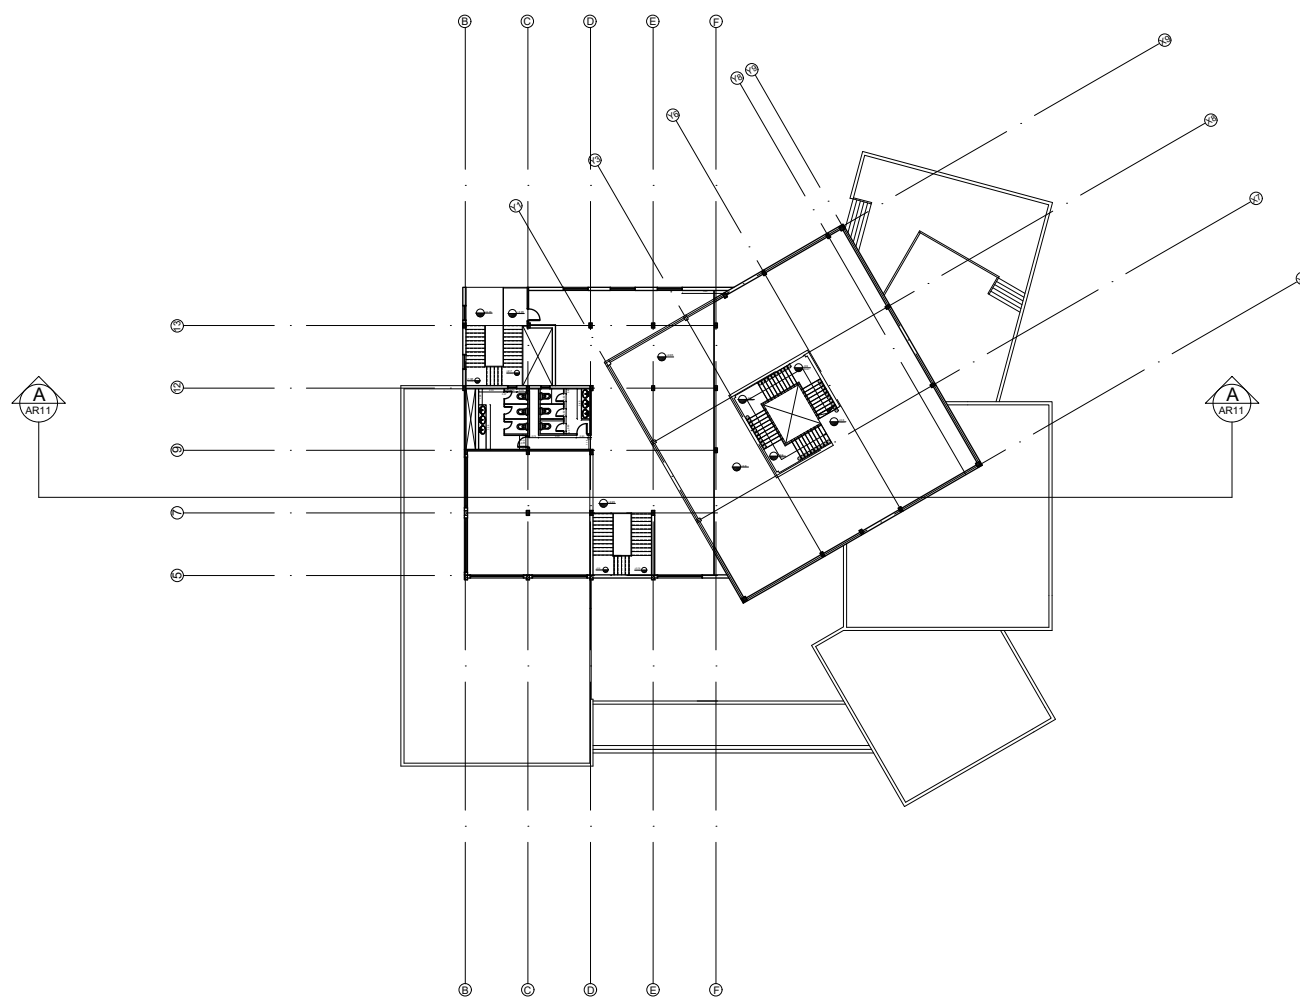

Key plan: First Floor Plan

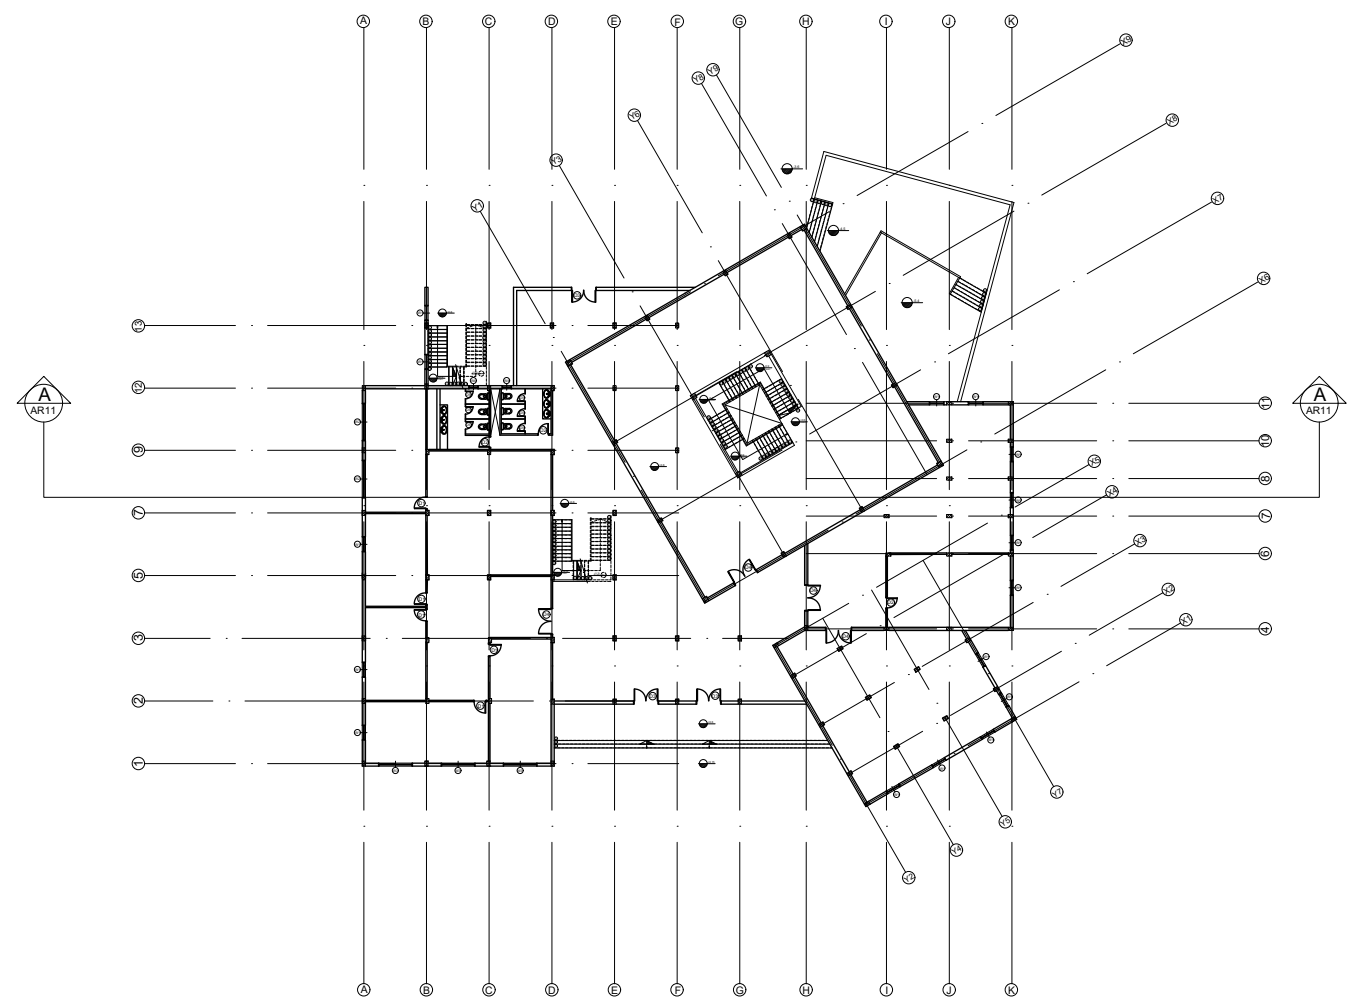

Key plan: Ground Floor Plan